


GREEN QWEEN

SHERMAN OAKS



ALL IDEAS, DESIGNS, ARRANGEMENTS INDICATED ON THESE PROJECT DOCUMENTS ARE THE PROPERTY OF SEVENPOINT INTERIORS. DRAWINGS ARE FOR REFERENCE ONLY, ARE INTENDED TO BE USED WITH THIS SPECIFIC PROJECT, AND SHALL NOT OTHERWISE BE MODIFIED OR REPRODUCED FOR ANY PURPOSE WITHOUT THE WRITTEN AUTHORIZATION OF SEVENPOINT INTERIORS. SITE MEASURE IS REQUIRED BY TRADES PRIOR TO COMMENCING ANY WORK. DIMENSIONS ON DRAWINGS ARE ONLY APPROXIMATE. ALL VIEWS, DRAWINGS, DIAGRAMS ARE CONCEPTUAL AND MAY BE SUBJECT TO CHANGE. MATERIAL REFERENCE IMAGES ON SCREEN AND IN PRINT MAY DIFFER FROM ACTUAL PRODUCT. REFER TO PHYSICAL SAMPLE.

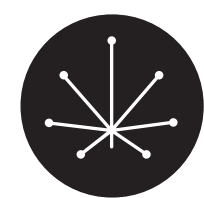

DESIGNED BY
SEVENPOINT INTERIORS

CONTACT
DESMOND@COFODESIGN.COM / JANE@COFODESIGN.COM

ADDRESS
21 REGINA ROAD, WOODBRIDGE, ONTARIO, CANADA, L4L 8L9



PROJECT
GREEN QWEEN - SHERMAN OAKS



CLIENT
TAYLOR BAZLEY / ANDRES RIGAL

ADDRESS
SHERMAN OAKS, CA


NO.	ISSUANCE	DATE	DRAWING TITLE	
4	MATERIALS REVIEW	JUN-13-2024		
5	CLIENT REVIEW	JUN-21-2024		
6	CLIENT REVIEW [R1]	JUL-11-2024		
7	HR1	JUL-22-2024	SCALE	N/A
8	HR2	JUL-25-2024	RETAIL AREA	795 SQFT
			PROPOSAL NO.	XX-XXXX-XX

COVER PAGE

1

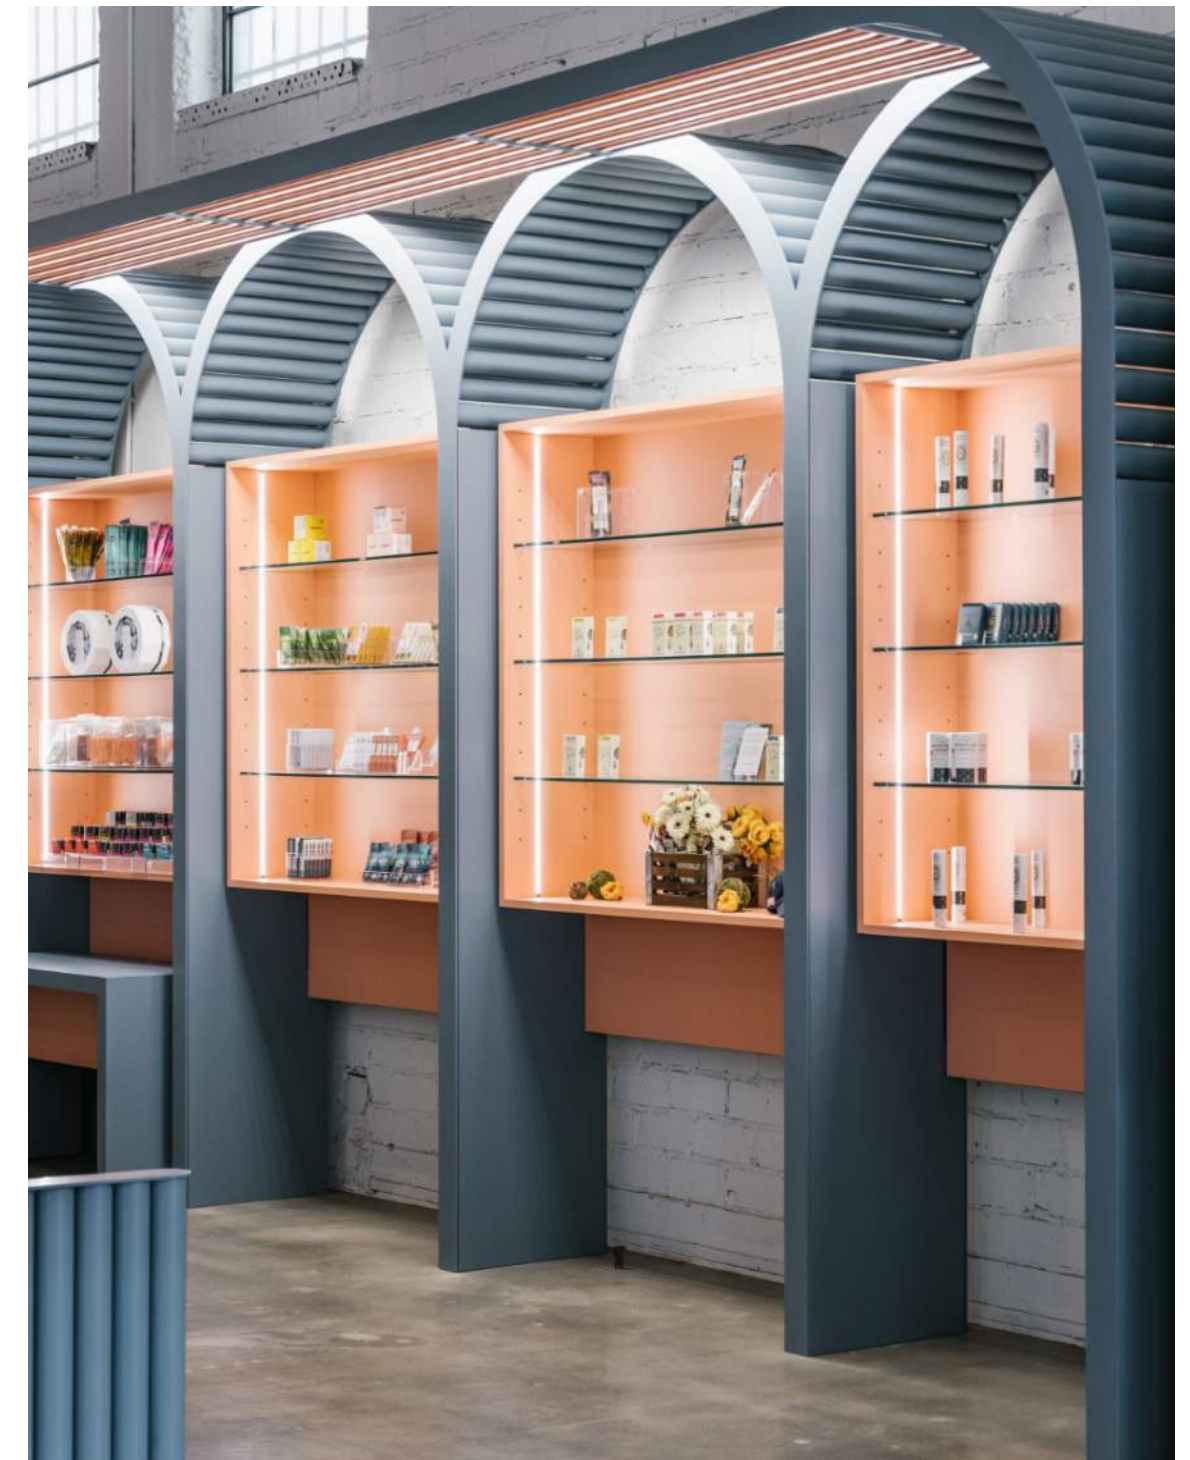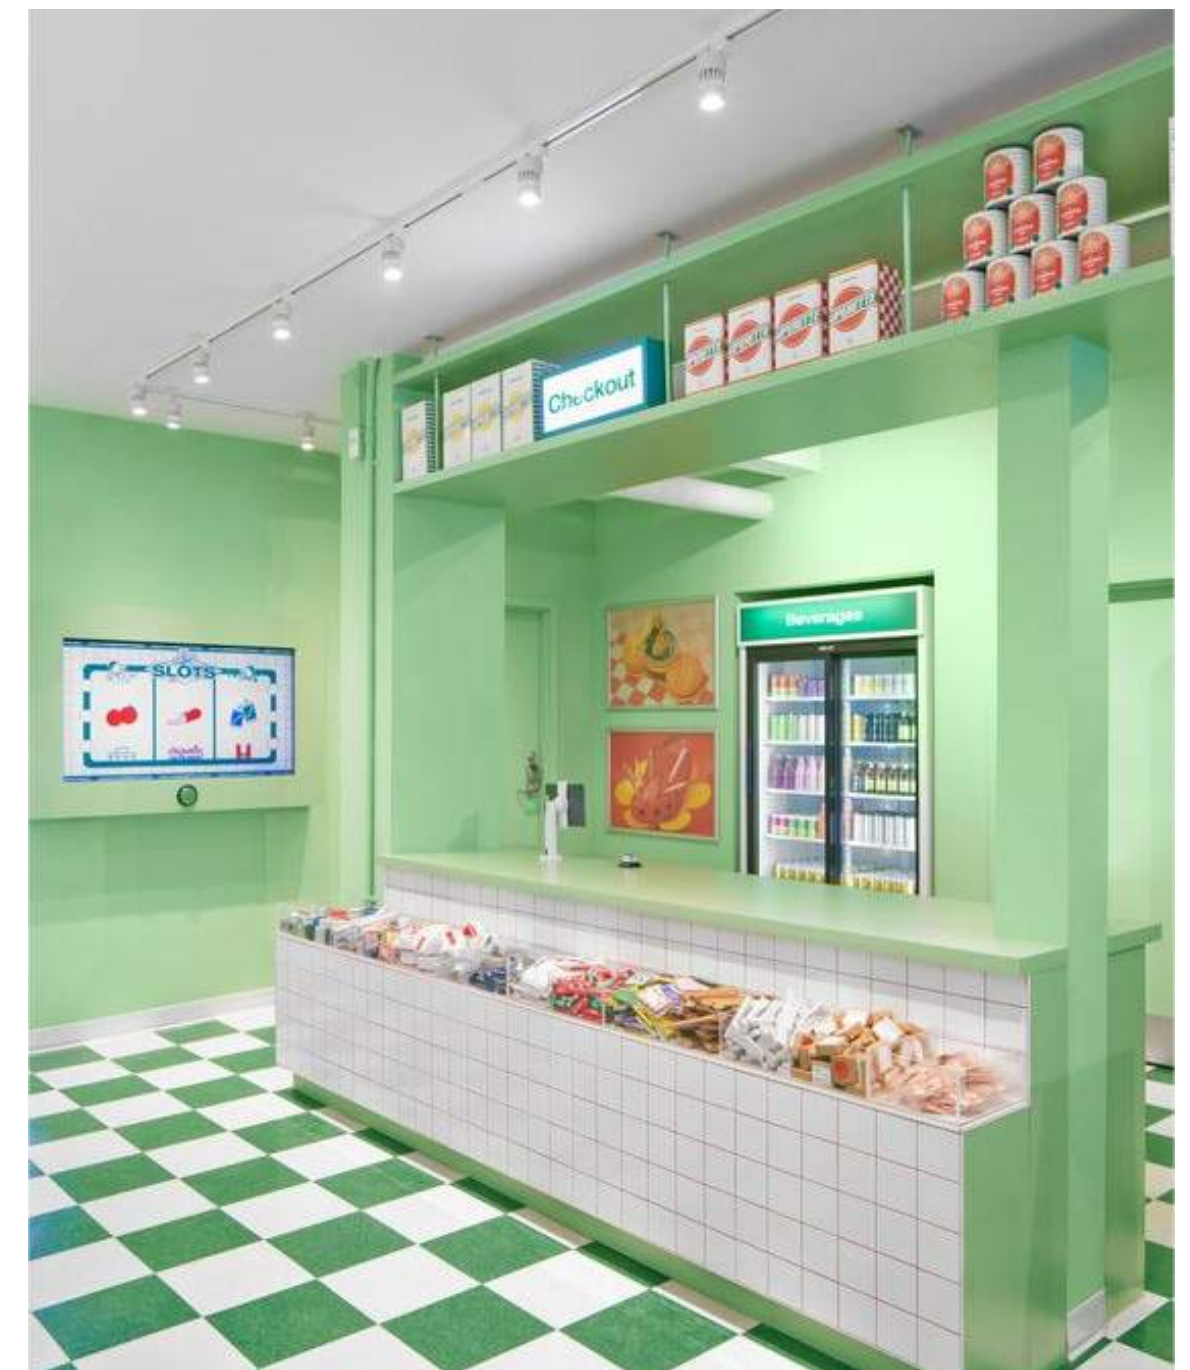

ALL IDEAS, DESIGNS, ARRANGEMENTS INDICATED ON THESE PROJECT DOCUMENTS ARE THE PROPERTY OF SEVENPOINT INTERIORS. DRAWINGS ARE FOR REFERENCE ONLY. ARE INTENDED TO BE USED WITH THIS SPECIFIC PROJECT, AND SHALL NOT OTHERWISE BE MODIFIED OR REPRODUCED FOR ANY PURPOSE WITHOUT THE WRITTEN AUTHORIZATION OF SEVENPOINT INTERIORS. SITE MEASURE IS REQUIRED BY TRADES PRIOR TO COMMENCING ANY WORK. DIMENSIONS ON DRAWINGS ARE ONLY APPROXIMATE. ALL VIEWS, DRAWINGS, DIAGRAMS ARE CONCEPTUAL AND MAY BE SUBJECT TO CHANGE. MATERIAL REFERENCE IMAGES ON SCREEN AND IN PRINT MAY DIFFER FROM ACTUAL PRODUCT. REFER TO PHYSICAL SAMPLE.

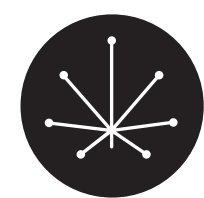

DESIGNED BY
SEVENPOINT INTERIORS

CONTACT
DESMOND@COFODESIGN.COM / JANE@COFODESIGN.COM

ADDRESS
21 REGINA ROAD, WOODBRIDGE, ONTARIO, CANADA, L4L 8L9










 






PROJECT
GREEN QWEEN - SHERMAN OAKS

CLIENT
TAYLOR BAZLEY / ANDRES RIGAL


ADDRESS
SHERMAN OAKS, CA

NO.	ISSUANCE	DATE	DRAWING TITLE	
4	MATERIALS REVIEW	JUN-13-2024		
5	CLIENT REVIEW	JUN-21-2024		
6	CLIENT REVIEW [R1]	JUL-11-2024	SCALE	N/A
7	HR1	JUL-22-2024	RETAIL AREA	795 SQFT
8	HR2	JUL-25-2024	PROPOSAL NO.	XX-XXXX-XX

  PAGE NO.
2

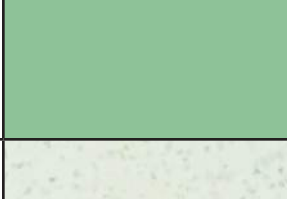FINISH SCHEDULE										SCOPE	
TAG	IMAGE	DESCRIPTION	SUPPLIER	COLLECTION	COLOUR	PRODUCT CODE	FINISH	SIZE	NOTES	SPI	G.C.
BB.01		JOHNSONITE RECESS TOELESS 4 1/4" WALL BASE	TARKETT	TOELESS	SNOW WHITE	RWDCT	-	4 1/4"H			X
G.01		SPECTRUM DICHROIC WITH ADHESIVE	DECORATIVE FILM	SOLYX	-	SX-3065	-	60"W			X
L.01		FIXTURE MILLWORK LAMINATE	ABET LAMINATI	-	445	-	SEI	-	SEE SEVENPOINT INTERIORS FIXTURE BREAKOUT FOR MORE APPLICATION	X	
L.02		FIXTURE MILLWORK LAMINATE	ABET LAMINATI	-	412	-	SEI	-		X	
L.03		FIXTURE MILLWORK LAMINATE	FORMICA	-	SOLAR ORANGE	8235-PX	PLEX (FINE DOTTED TEXTURE)	-		X	
L.04		FIXTURE MILLWORK LAMINATE	ABET LAMINATI	-	454	-	SEI	-		X	
M.01		CUSTOM POWDER METAL COAT	SEVENPOINT INTERIORS	-	TO MATCH ABET LAMINATI 445	-	SATIN	-		X	
M.02		CUSTOM POWDER METAL COAT	SEVENPOINT INTERIORS	-	TO MATCH ABET LAMINATI 412	-	SATIN	-		X	
M.03		CUSTOM POWDER METAL COAT	SEVENPOINT INTERIORS	-	TO MATCH L.03	-	SATIN	-		X	
P.01		MAIN CEILING PAINT	SHERWIN WILLIAMS	-	RACHEL PINK	SW 0026	EGGSHELL	-			X
P.02		ACCENT CEILING PAINT	SHERWIN WILLIAMS	-	POTENTIALLY PURPLE	SW 6821	EGGSHELL	-	CEILING PAINT TO CONTINUE TO CROWN MOULDING. SEE DRAWING AND RENDERINGS FOR REFERENCE.		X
P.03		ACCENT WALL PAINT	SHERWIN WILLIAMS	-	CERTAIN PEACH	SW 6625	EGGSHELL	-			X
P.04		HVAC DUCT PAINT	SHERWIN WILLIAMS	-	VEGAN	SW 6738	EGGSHELL	-			X
SS.01		SOLID SURFACE COUNTERTOP	DURAT	-	LIGHT GREEN	190	-	114" x 31.5" x 0.5"	SEE SEVENPOINT INTERIORS FIXTURE BREAKOUT FOR MORE APPLICATION	X	

ALL IDEAS, DESIGNS, ARRANGEMENTS INDICATED ON THESE PROJECT DOCUMENTS ARE THE PROPERTY OF SEVENPOINT INTERIORS. DRAWINGS ARE FOR REFERENCE ONLY, ARE INTENDED TO BE USED WITH THIS SPECIFIC PROJECT, AND SHALL NOT OTHERWISE BE MODIFIED OR REPRODUCED FOR ANY PURPOSE WITHOUT THE WRITTEN AUTHORIZATION OF SEVENPOINT INTERIORS. SITE MEASURE IS REQUIRED BY TRADES PRIOR TO COMMENCING ANY WORK. DIMENSIONS ON DRAWINGS ARE ONLY APPROXIMATE. ALL VIEWS, DRAWINGS, DIAGRAMS ARE CONCEPTUAL AND MAY BE SUBJECT TO CHANGE. MATERIAL REFERENCE IMAGES ON SCREEN AND IN PRINT MAY DIFFER FROM ACTUAL PRODUCT. REFER TO PHYSICAL SAMPLE.

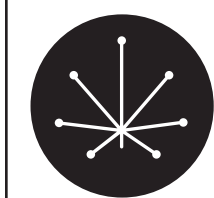

DESIGNED BY
SEVENPOINT INTERIORS

CONTACT
DESMOND@COFODESIGN.COM / JANE@COFODESIGN.COM

ADDRESS
21 REGINA ROAD, WOODBRIDGE, ONTARIO, CANADA, L4L 8L9



PROJECT
GREEN QWEEN - SHERMAN OAKS






CLIENT
TAYLOR BAZLEY / ANDRES RIGAL




ADDRESS
SHERMAN OAKS, CA

NO.	ISSUANCE	DATE	DRAWING TITLE										
4	MATERIALS REVIEW	JUN-13-2024	<table border="1"> <tr> <td>SCALE</td> <td>N/A</td> <td rowspan="2">PAGE NO.</td> </tr> <tr> <td>RETAIL AREA</td> <td>795 SQFT</td> </tr> <tr> <td>PROPOSAL NO.</td> <td>XX-XXXX-XX</td> <td></td> </tr> </table>			SCALE	N/A	PAGE NO.	RETAIL AREA	795 SQFT	PROPOSAL NO.	XX-XXXX-XX	
SCALE	N/A	PAGE NO.											
RETAIL AREA	795 SQFT												
PROPOSAL NO.	XX-XXXX-XX												
5	CLIENT REVIEW	JUN-21-2024											
6	CLIENT REVIEW [R1]	JUL-11-2024											
7	HR1	JUL-22-2024											
8	HR2	JUL-25-2024											


SCHEDULES

3

FINISH SCHEDULE										SCOPE	
TAG	IMAGE	DESCRIPTION	SUPPLIER	COLLECTION	COLOUR	PRODUCT CODE	FINISH	SIZE	NOTES	SPI	G.C.
T.01		ENTRANCE 2X4 STRAIGHT SET SHEETED MOSAIC ACCENT TILE	FIRECLAY TILE	2X4 STRAIGHT SET SHEETED	SEA GREEN	-	GLOSS (W/ENGOBE)	1-15/16" x 4"	PAIR WITH TEC STANDARD WHITE GROUT		X
T.02		ENTRANCE 2X4 STRAIGHT SET SHEETED MOSAIC ACCENT TILE	FIRECLAY TILE	2X4 STRAIGHT SET SHEETED	SEA GLASS	-	GLOSS (W/ENGOBE)	1-15/16" x 4"	PAIR WITH TEC STANDARD WHITE GROUT		X
T.03		MAIN RETAIL AREA FLOOR TILE	CONCRETE COLLABORATIVE	VENICE LARGE	ALABASTER EVERGREEN	-	-	24" X 24" 3/4"	PAIR WITH TEC SILVERADO GROUT		X
T.04		BACK RETAIL AREA FLOOR TILE	CONCRETE COLLABORATIVE	VENICE LARGE	ALABASTER POLEMO MIX	-	-	24" X 24" X 3/4"	PAIR WITH TEC SILVERADO GROUT		X
WC.01		CASH DESK ACCENT TAMBOUR	RICHELIEU	DECORTAMBOUR SOLID WOODS	LACQUERED TO MATCH ABET LAMINATI 412	TB383R08	-			X	
WC.02		MAIN RETAIL AREA WALLPAPER	HOVIA	OMBRE FADE	PEACH & TURQUOISE	OM0023NE01W	-	CUSTOMIZE TO FILL WALLS			X
WC.03		BACK RETAIL AREA WALLPAPER	SPOONFLOWER	JUMBO RETRO CHECKERBOARD	PAPAYA ORANGE	-	-	CUSTOMIZE TO FILL WALLS			X

LIGHTING SCHEDULE										SCOPE	
TAG	IMAGE	DESCRIPTION	SUPPLIER	COLLECTION	COLOUR	PRODUCT CODE	QUANTITY	SIZE	NOTES	SPI	G.C.
LT.01		ARCHITECTURAL LED RECESSED DOWNLIGHT	ALCON LIGHTING	14142	WHITE	14142-R-ADJ-B38-WH-40K	6	3"W X 3"L X 4"H			X
LT.02		KAMI CEILING LAMP	VAKKERLIGHT	KAMI CEILING LAMP	GREEN	FANYE-230850-1	5	11.8"W X 6.2"H			X
LT.03		MULTI-SIZED LED TRACK LIGHT HEAD	ALCON LIGHTING	-	WHITE	13340	16	LARGE	PAIR WITH LT.04		X
LT.04		6"W BOLA SPHERE PENDANT	LIGHTOLOGY	BOLA SPHERE PENDANT	ROSE GOLD	PBL874304	2	6"W			X
LT.05		12"W BOLA SPHERE PENDANT	LIGHTOLOGY	BOLA SPHERE PENDANT	ROSE GOLD	PBL874304	2	12"W			X
LT.06		16"W BOLA SPHERE PENDANT	LIGHTOLOGY	BOLA SPHERE PENDANT	ROSE GOLD	PBL874307	1	16"W			X

ALL IDEAS, DESIGNS, ARRANGEMENTS INDICATED ON THESE PROJECT DOCUMENTS ARE THE PROPERTY OF SEVENPOINT INTERIORS. DRAWINGS ARE FOR REFERENCE ONLY, ARE INTENDED TO BE USED WITH THIS SPECIFIC PROJECT, AND SHALL NOT OTHERWISE BE MODIFIED OR REPRODUCED FOR ANY PURPOSE WITHOUT THE WRITTEN AUTHORIZATION OF SEVENPOINT INTERIORS. SITE MEASURE IS REQUIRED BY TRADES PRIOR TO COMMENCING ANY WORK. DIMENSIONS ON DRAWINGS ARE ONLY APPROXIMATE. ALL VIEWS, DRAWINGS, DIAGRAMS ARE CONCEPTUAL AND MAY BE SUBJECT TO CHANGE. MATERIAL REFERENCE IMAGES ON SCREEN AND IN PRINT MAY DIFFER FROM ACTUAL PRODUCT. REFER TO PHYSICAL SAMPLE.

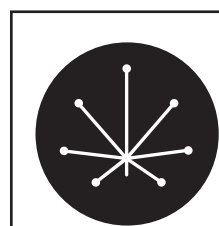

DESIGNED BY
SEVENPOINT INTERIORS

CONTACT
DESMOND@COFODESIGN.COM / JANE@COFODESIGN.COM

ADDRESS
21 REGINA ROAD, WOODBRIDGE, ONTARIO, CANADA, L4L 8L9







PROJECT
GREEN QWEEN - SHERMAN OAKS

CLIENT
TAYLOR BAZLEY / ANDRES RIGAL


ADDRESS
SHERMAN OAKS, CA

NO.	ISSUANCE	DATE	DRAWING TITLE												
4	MATERIALS REVIEW	JUN-13-2024	<table border="1"> <tr> <td>SCALE</td> <td>N/A</td> <td rowspan="2">PAGE NO.</td> </tr> <tr> <td>RETAIL AREA</td> <td>795 SQFT</td> </tr> <tr> <td>PROPOSAL NO.</td> <td>XX-XXXX-XX</td> <td rowspan="2"> <div style="text-align: right; font-size: 2em; font-weight: bold;">4</div> </td> </tr> <tr> <td colspan="2"></td> </tr> </table>			SCALE	N/A	PAGE NO.	RETAIL AREA	795 SQFT	PROPOSAL NO.	XX-XXXX-XX	<div style="text-align: right; font-size: 2em; font-weight: bold;">4</div>		
SCALE	N/A	PAGE NO.													
RETAIL AREA	795 SQFT														
PROPOSAL NO.	XX-XXXX-XX	<div style="text-align: right; font-size: 2em; font-weight: bold;">4</div>													
5	CLIENT REVIEW	JUN-21-2024													
6	CLIENT REVIEW [R1]	JUL-11-2024													
7	HR1	JUL-22-2024													
8	HR2	JUL-25-2024													

TRIMWORK SCHEDULE										SCOPE	
TAG	IMAGE	DESCRIPTION	SUPPLIER	COLLECTION	COLOUR	PRODUCT CODE	FINISH	SIZE	NOTES	SPI	G.C.
TR.01		PRIMED WHITE PLAIN POLYURETHANE CROWN MOULDING	HOME DEPOT	ORAC DECOR	FINISHED IN P.02	1009535329	-	2" X 2" X 78-3/4"	G.C. TO SPECIFY, SUPPLY AND INSTALL 3500K LED LIGHT STRIP. SEE DRAWINGS FOR MORE INFORMATION.		X

EMERGENCY SAFETY DEVICES STYLE GUIDE (REFERENCE ONLY)				SCOPE	
IMAGE	DESCRIPTION	COLOUR	NOTES		
	SLIM RECESSED-MOUNT EDGE LIT LED EXIT SIGN	WHITE	DEVICES SHOWN ARE FOR DESIGN STYLE REFERENCE ONLY. G.C. TO CONFIRM SPECIFICATIONS, LOCATIONS, MOUNTING AND QUANTITY REQUIREMENTS WITH LOCAL REGULATIONS. G.C. TO SUPPLY AND INSTALL.		
	EMERGENCY LIGHT	WHITE			
	WALL-MOUNTED FIRE ALARM SPEAKER STROBE	WHITE			
			G.C. TO SUPPLY AND INSTALL		


ALL IDEAS, DESIGNS, ARRANGEMENTS INDICATED ON THESE PROJECT DOCUMENTS ARE THE PROPERTY OF SEVENPOINT INTERIORS. DRAWINGS ARE FOR REFERENCE ONLY, ARE INTENDED TO BE USED WITH THIS SPECIFIC PROJECT, AND SHALL NOT OTHERWISE BE MODIFIED OR REPRODUCED FOR ANY PURPOSE WITHOUT THE WRITTEN AUTHORIZATION OF SEVENPOINT INTERIORS. SITE MEASURE IS REQUIRED BY TRADES PRIOR TO COMMENCING ANY WORK. DIMENSIONS ON DRAWINGS ARE ONLY APPROXIMATE. ALL VIEWS, DRAWINGS, DIAGRAMS ARE CONCEPTUAL AND MAY BE SUBJECT TO CHANGE. MATERIAL REFERENCE IMAGES ON SCREEN AND IN PRINT MAY DIFFER FROM ACTUAL PRODUCT. REFER TO PHYSICAL SAMPLE.

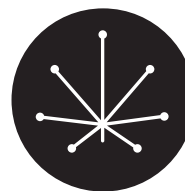

DESIGNED BY
SEVENPOINT INTERIORS

CONTACT
DESMOND@COFODESIGN.COM / JANE@COFODESIGN.COM

ADDRESS
21 REGINA ROAD, WOODBRIDGE, ONTARIO, CANADA, L4L 8L9




PROJECT
GREEN QWEEN - SHERMAN OAKS

CLIENT
TAYLOR BAZLEY / ANDRES RIGAL

ADDRESS
SHERMAN OAKS, CA

NO.	ISSUANCE	DATE	DRAWING TITLE		
4	MATERIALS REVIEW	JUN-13-2024	SCHEDULES		
5	CLIENT REVIEW	JUN-21-2024			
6	CLIENT REVIEW [R1]	JUL-11-2024			
7	HR1	JUL-22-2024	SCALE	N/A	PAGE NO.
8	HR2	JUL-25-2024	RETAIL AREA	795 SQFT	
			PROPOSAL NO.	XX-XXXX-XX	5

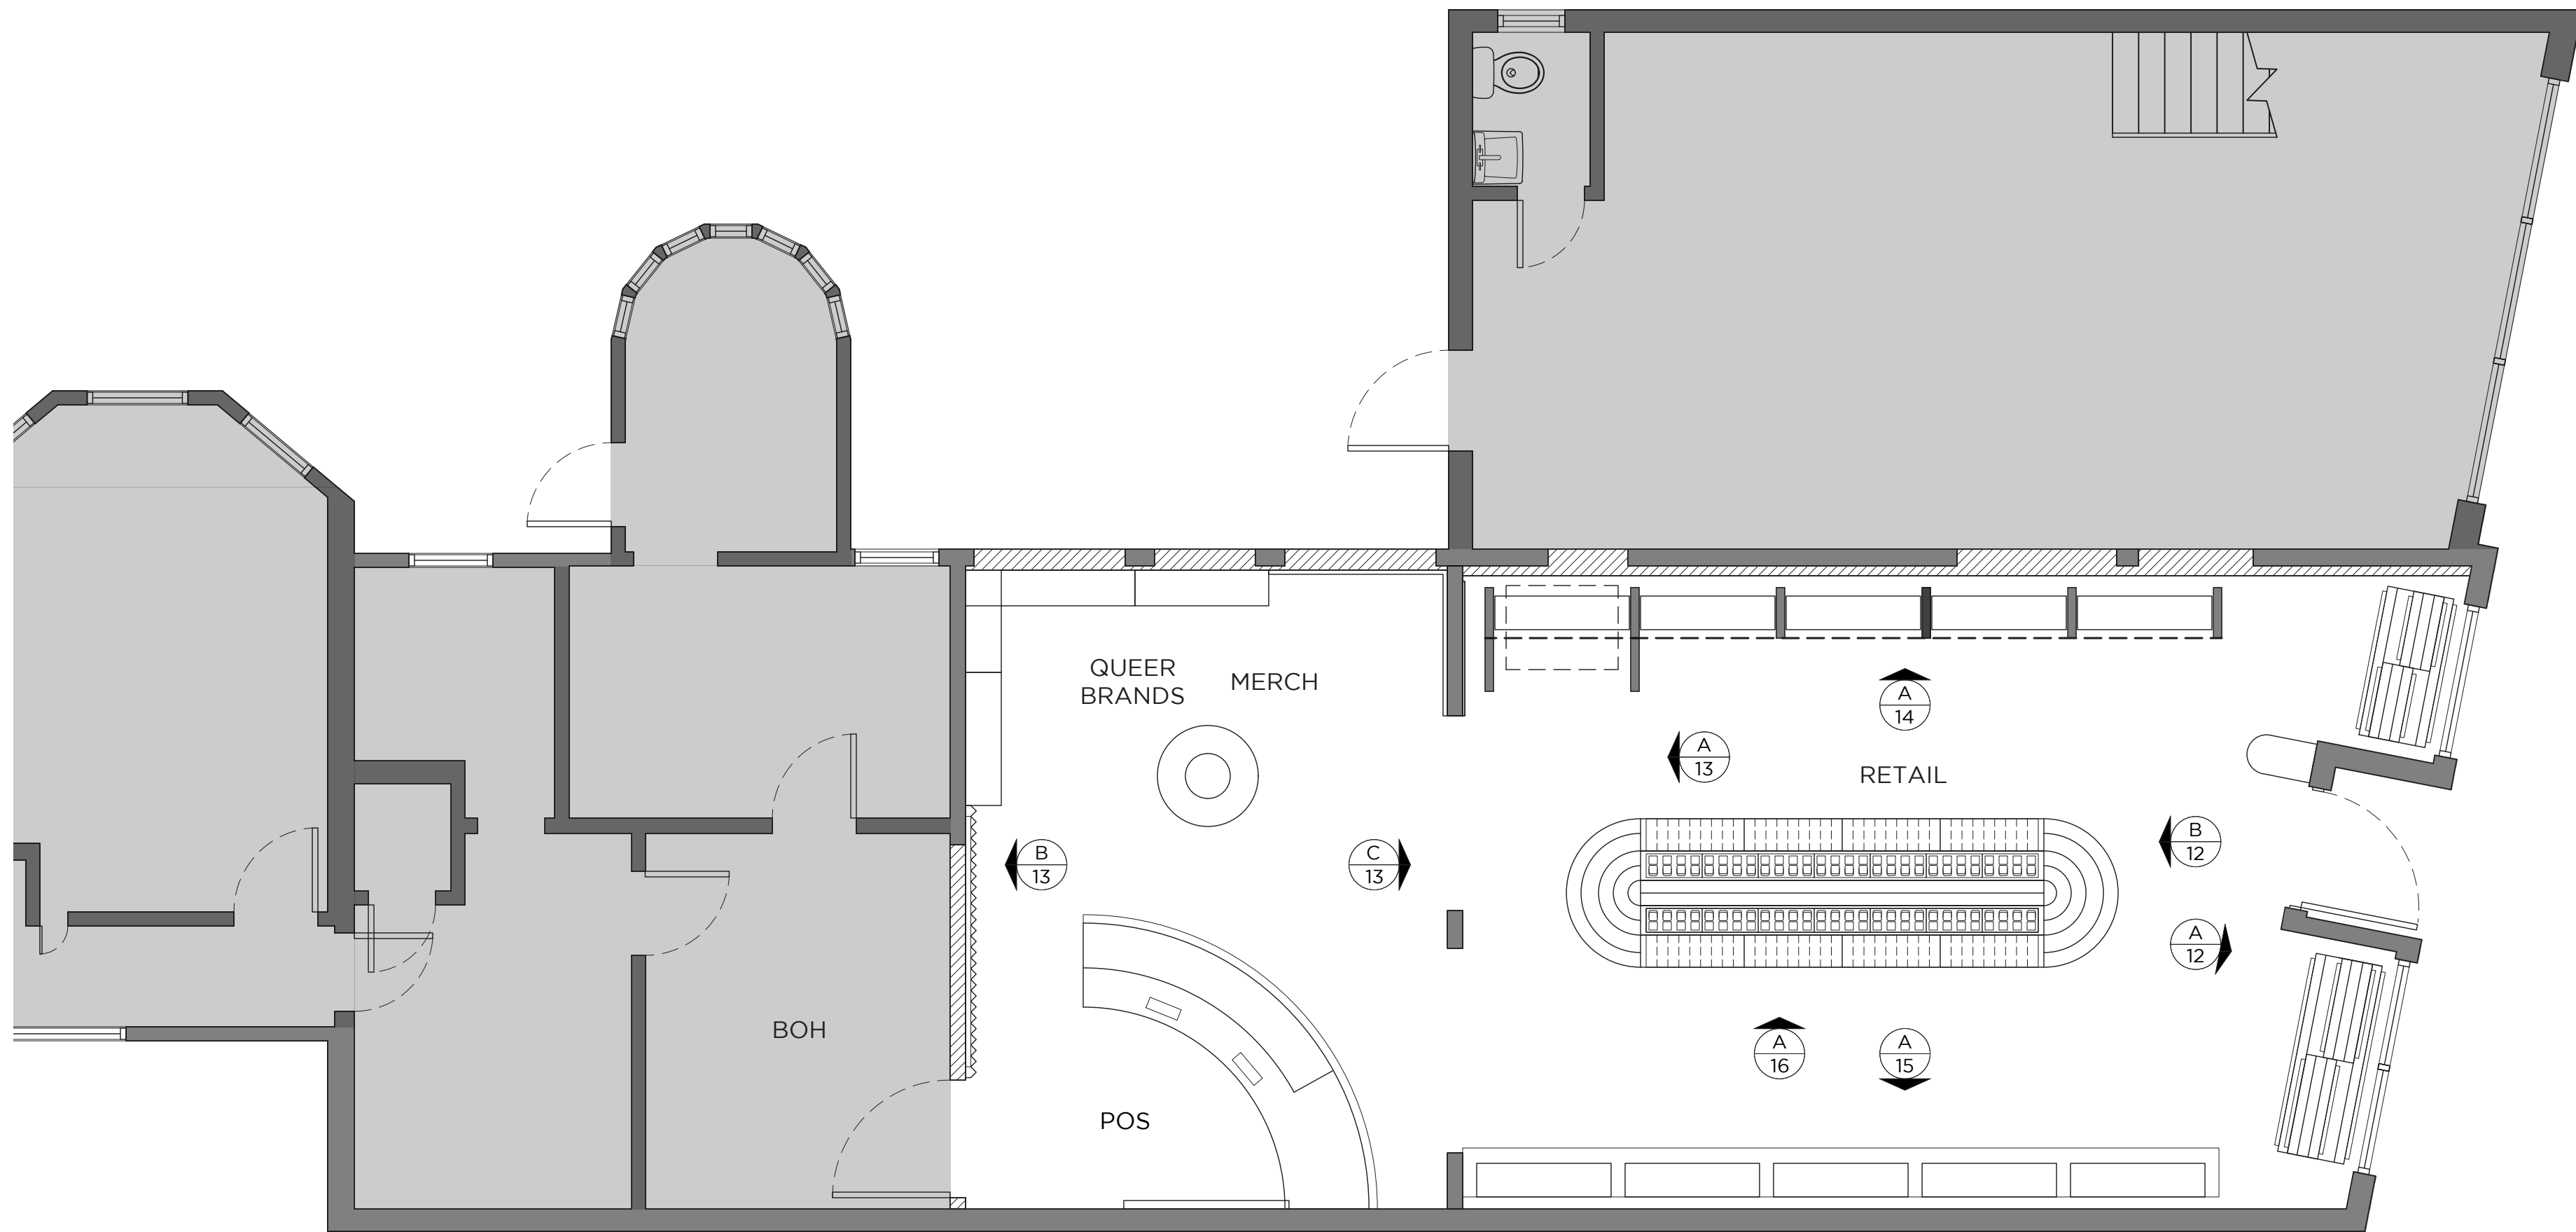

A/5 FLOOR PLAN

ALL IDEAS, DESIGNS, ARRANGEMENTS INDICATED ON THESE PROJECT DOCUMENTS ARE THE PROPERTY OF SEVENPOINT INTERIORS. DRAWINGS ARE FOR REFERENCE ONLY, ARE INTENDED TO BE USED WITH THIS SPECIFIC PROJECT, AND SHALL NOT OTHERWISE BE MODIFIED OR REPRODUCED FOR ANY PURPOSE WITHOUT THE WRITTEN AUTHORIZATION OF SEVENPOINT INTERIORS. SITE MEASURE IS REQUIRED BY TRADES PRIOR TO COMMENCING ANY WORK. DIMENSIONS ON DRAWINGS ARE ONLY APPROXIMATE. ALL VIEWS, DRAWINGS, DIAGRAMS ARE CONCEPTUAL AND MAY BE SUBJECT TO CHANGE. MATERIAL REFERENCE IMAGES ON SCREEN AND IN PRINT MAY DIFFER FROM ACTUAL PRODUCT. REFER TO PHYSICAL SAMPLE.

DESIGNED BY
SEVENPOINT INTERIORS

CONTACT
DESMOND@COFODESIGN.COM / JANE@COFODESIGN.COM

ADDRESS
21 REGINA ROAD, WOODBRIDGE, ONTARIO, CANADA, L4L 8L9


PROJECT
GREEN QWEEN - SHERMAN OAKS

CLIENT
TAYLOR BAZLEY / ANDRES RIGAL

ADDRESS
SHERMAN OAKS, CA


NO.	ISSUANCE	DATE	DRAWING TITLE	
4	MATERIALS REVIEW	JUN-13-2024	<div style="display: flex; justify-content: space-between;"> SCALE N/A </div> <div style="display: flex; justify-content: space-between;"> RETAIL AREA 795 SQFT </div> <div style="display: flex; justify-content: space-between;"> PROPOSAL NO. XX-XXXX-XX </div>	
5	CLIENT REVIEW	JUN-21-2024		
6	CLIENT REVIEW [R1]	JUL-11-2024		
7	HR1	JUL-22-2024	<div style="display: flex; justify-content: space-between;"> SCALE N/A </div> <div style="display: flex; justify-content: space-between;"> RETAIL AREA 795 SQFT </div> <div style="display: flex; justify-content: space-between;"> PROPOSAL NO. XX-XXXX-XX </div>	
8	HR2	JUL-25-2024		

GENERAL NOTES
 FIXTURES SUPPLIED BY SEVENPOINT INTERIORS. G.C. TO PROVIDE BLOCKING AS REQUIRED FOR ALL WALL BAY FIXTURES. REFER TO SEVENPOINT INTERIORS FIXTURE BREAKOUTS AND INTERIOR DESIGN SCHEDULES FOR MORE INFORMATION.

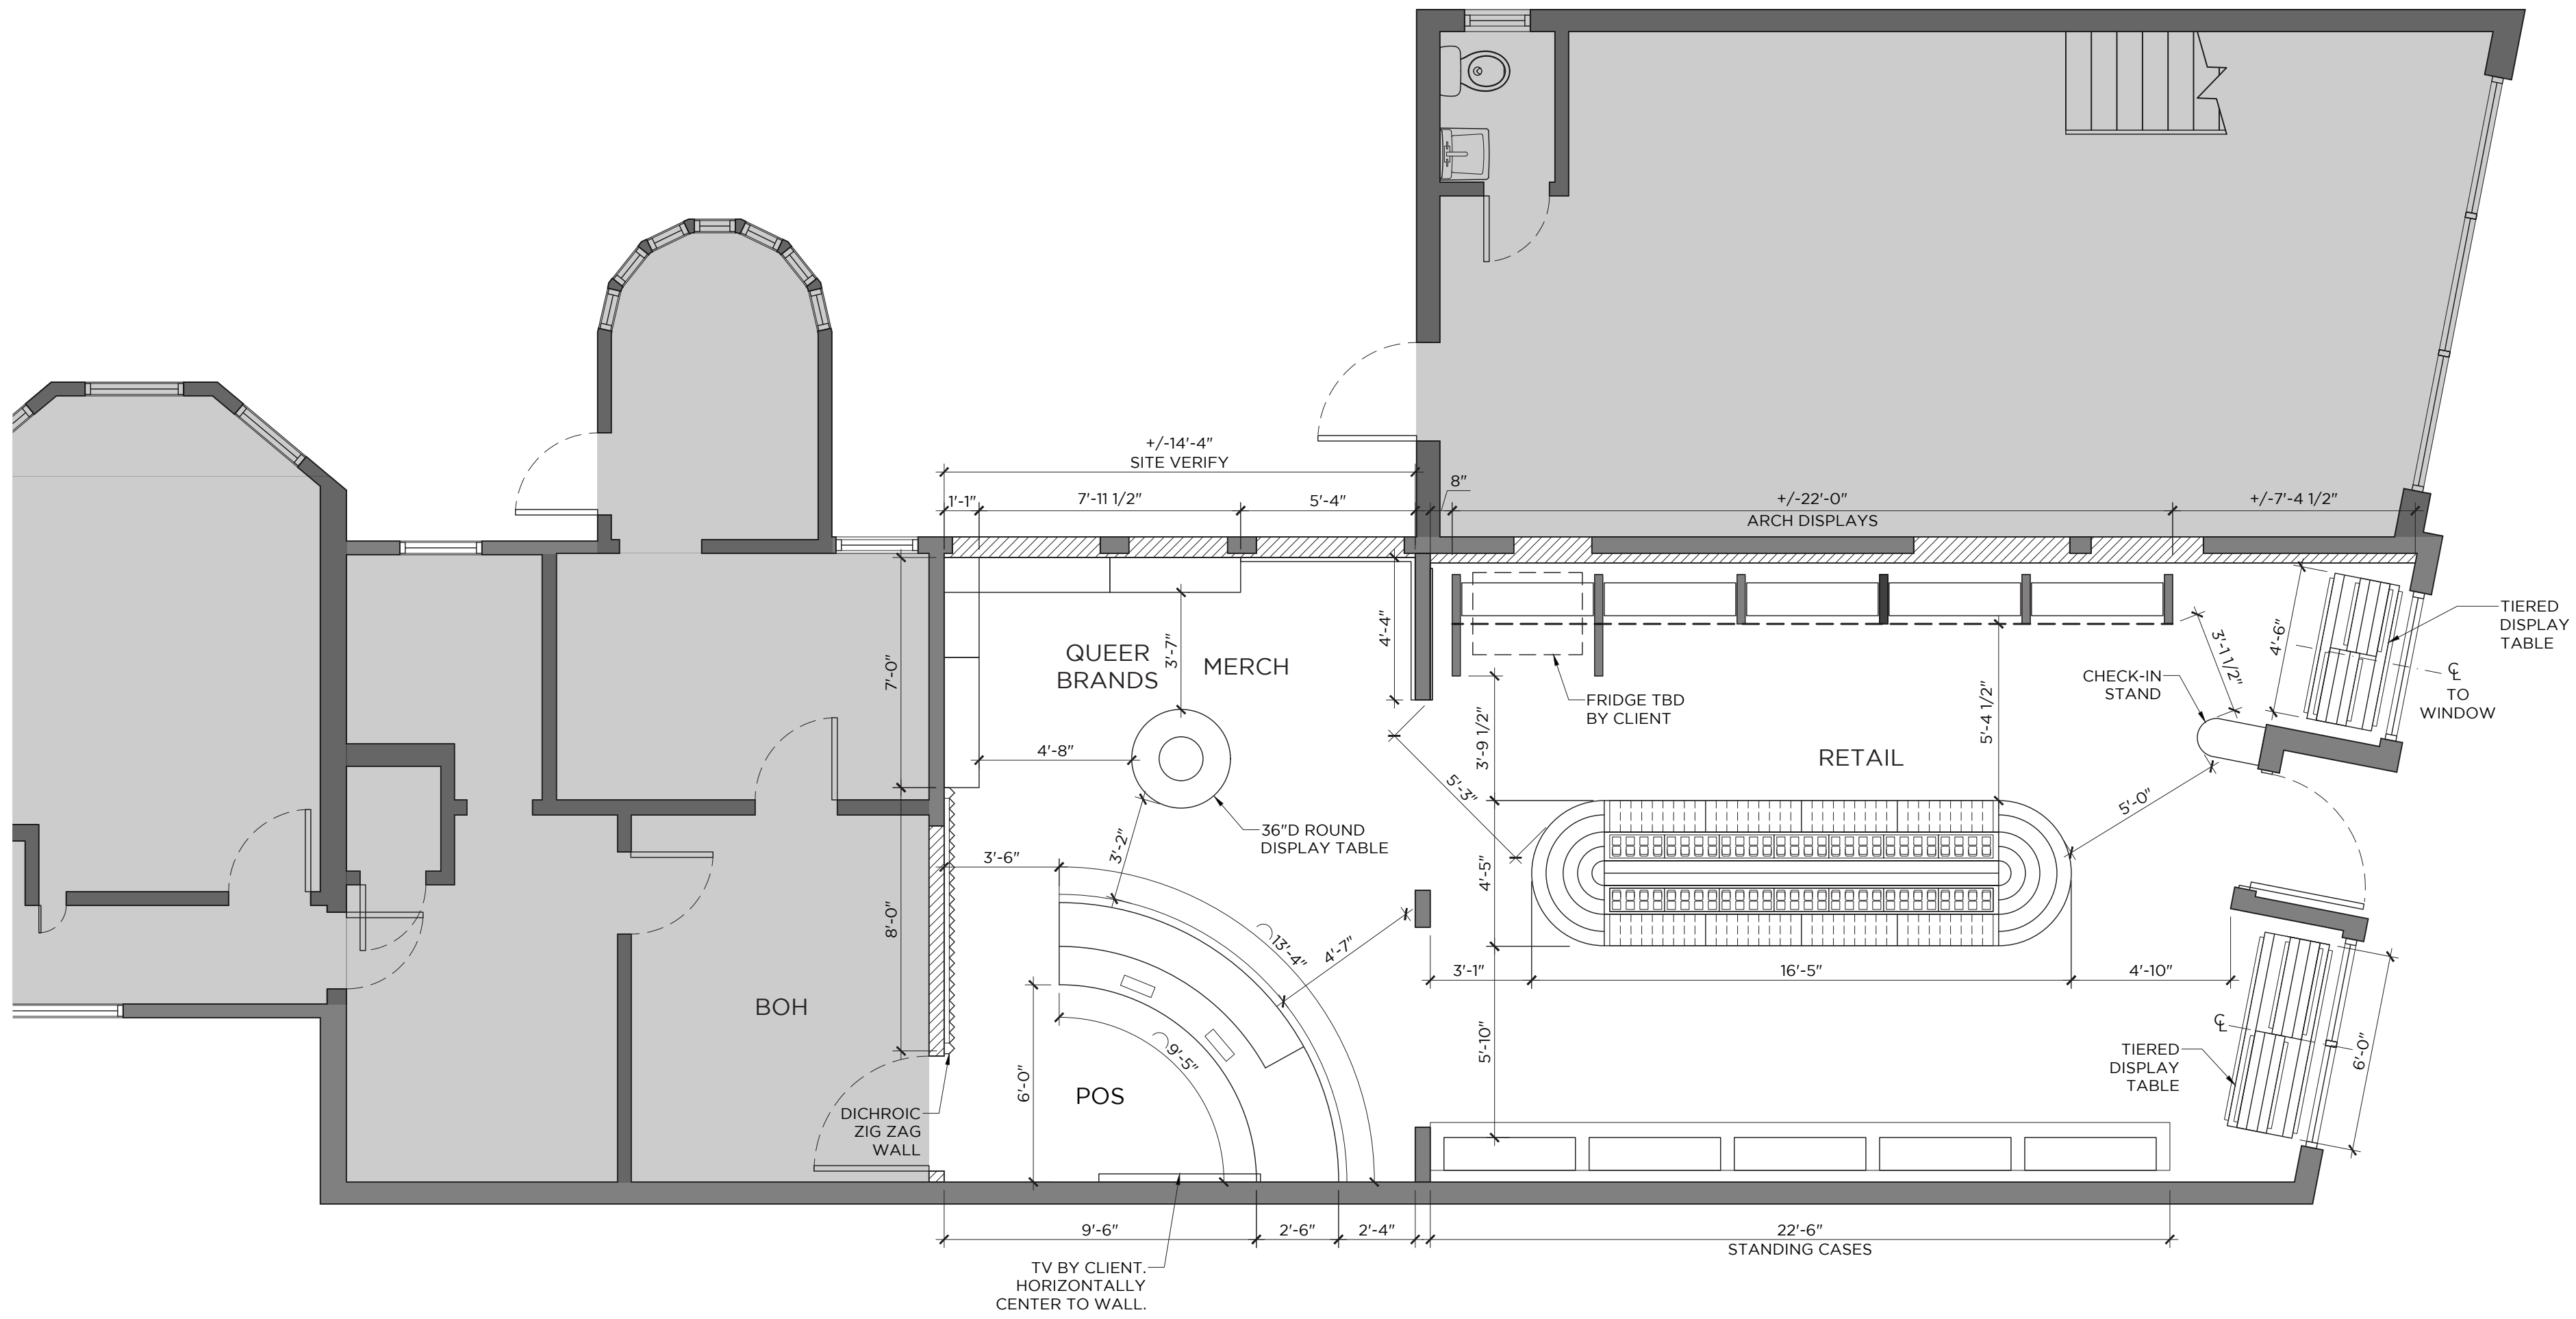

A
6 **FIXTURE PLAN**

ALL IDEAS, DESIGNS, ARRANGEMENTS INDICATED ON THESE PROJECT DOCUMENTS ARE THE PROPERTY OF SEVENPOINT INTERIORS. DRAWINGS ARE FOR REFERENCE ONLY. ARE INTENDED TO BE USED WITH THIS SPECIFIC PROJECT, AND SHALL NOT OTHERWISE BE MODIFIED OR REPRODUCED FOR ANY PURPOSE WITHOUT THE WRITTEN AUTHORIZATION OF SEVENPOINT INTERIORS. SITE MEASURE IS REQUIRED BY TRADES PRIOR TO COMMENCING ANY WORK. DIMENSIONS ON DRAWINGS ARE ONLY APPROXIMATE. ALL VIEWS, DRAWINGS, DIAGRAMS ARE CONCEPTUAL AND MAY BE SUBJECT TO CHANGE. MATERIAL REFERENCE IMAGES ON SCREEN AND IN PRINT MAY DIFFER FROM ACTUAL PRODUCT. REFER TO PHYSICAL SAMPLE.

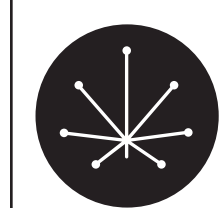

DESIGNED BY
SEVENPOINT INTERIORS

CONTACT
DESMOND@COFODESIGN.COM / JANE@COFODESIGN.COM

ADDRESS
21 REGINA ROAD, WOODBRIDGE, ONTARIO, CANADA, L4L 8L9




PROJECT
GREEN QWEEN - SHERMAN OAKS

CLIENT
TAYLOR BAZLEY / ANDRES RIGAL

ADDRESS
SHERMAN OAKS, CA

NO.	ISSUANCE	DATE	DRAWING TITLE	
4	MATERIALS REVIEW	JUN-13-2024	FIXTURE PLAN	
5	CLIENT REVIEW	JUN-21-2024		
6	CLIENT REVIEW [R1]	JUL-11-2024		
7	HR1	JUL-22-2024	SCALE	N/A
8	HR2	JUL-25-2024	RETAIL AREA	795 SQFT
			PROPOSAL NO.	XX-XXXX-XX
			PAGE NO.	7

GENERAL NOTES
 G.C. TO SUPPLY AND INSTALL. CONFIRM PARTITION THICKNESS ON SITE.
 REFER TO ARCHITECTURAL DRAWINGS FOR MORE INFORMATION.

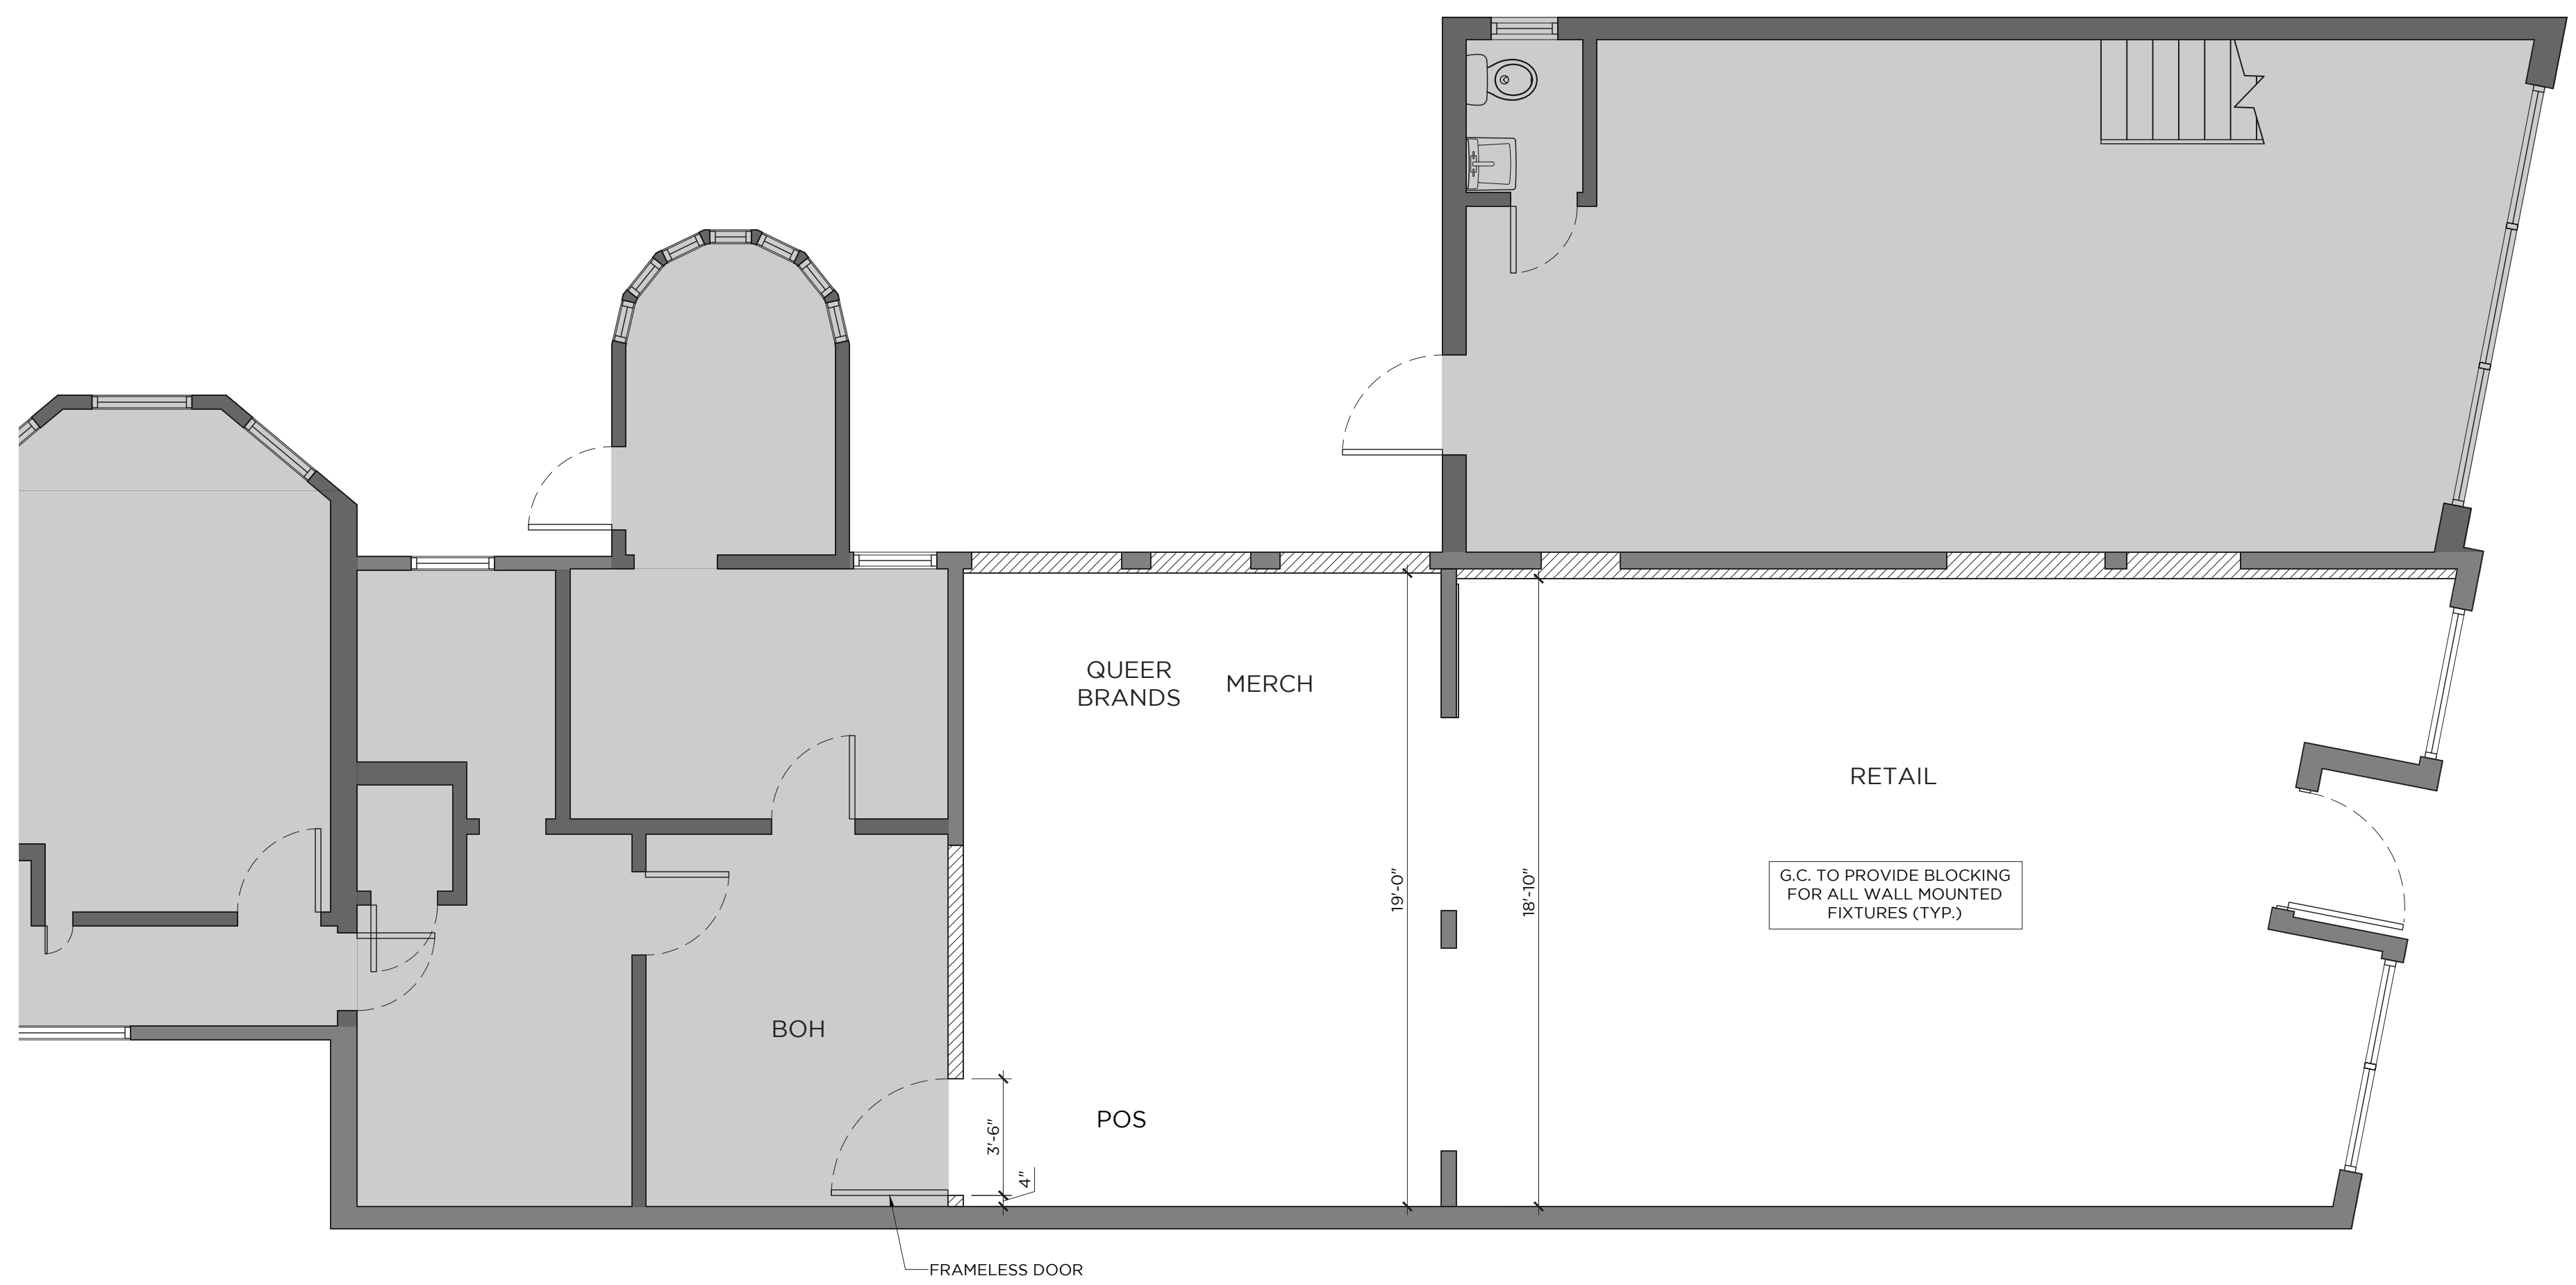

A PARTITION PLAN

ALL IDEAS, DESIGNS, ARRANGEMENTS INDICATED ON THESE PROJECT DOCUMENTS ARE THE PROPERTY OF SEVENPOINT INTERIORS. DRAWINGS ARE FOR REFERENCE ONLY. ARE INTENDED TO BE USED WITH THIS SPECIFIC PROJECT, AND SHALL NOT OTHERWISE BE MODIFIED OR REPRODUCED FOR ANY PURPOSE WITHOUT THE WRITTEN AUTHORIZATION OF SEVENPOINT INTERIORS. SITE MEASURE IS REQUIRED BY TRADES PRIOR TO COMMENCING ANY WORK. DIMENSIONS ON DRAWINGS ARE ONLY APPROXIMATE. ALL VIEWS, DRAWINGS, DIAGRAMS ARE CONCEPTUAL AND MAY BE SUBJECT TO CHANGE. MATERIAL REFERENCE IMAGES ON SCREEN AND IN PRINT MAY DIFFER FROM ACTUAL PRODUCT. REFER TO PHYSICAL SAMPLE.

DESIGNED BY
SEVENPOINT INTERIORS

CONTACT
DESMOND@COFODESIGN.COM / JANE@COFODESIGN.COM

ADDRESS
21 REGINA ROAD, WOODBRIDGE, ONTARIO, CANADA, L4L 8L9




PROJECT
GREEN QWEEN - SHERMAN OAKS

CLIENT
TAYLOR BAZLEY / ANDRES RIGAL

ADDRESS
SHERMAN OAKS, CA

NO.	ISSUANCE	DATE	DRAWING TITLE	
4	MATERIALS REVIEW	JUN-13-2024	PARTITION PLAN SCALE N/A RETAIL AREA 795 SQFT PROPOSAL NO. XX-XXXX-XX PAGE NO. 8	
5	CLIENT REVIEW	JUN-21-2024		
6	CLIENT REVIEW [R1]	JUL-11-2024		
7	HR1	JUL-22-2024		
8	HR2	JUL-25-2024		

GENERAL NOTES
 REFER TO ARCHITECTURAL DRAWINGS AND INTERIOR DESIGN SCHEDULES FOR MORE INFORMATION. G.C. TO COORDINATE WITH AUDIO/VISUAL TECHNICIAN FOR A/V SUPPLY AND INSTALL.

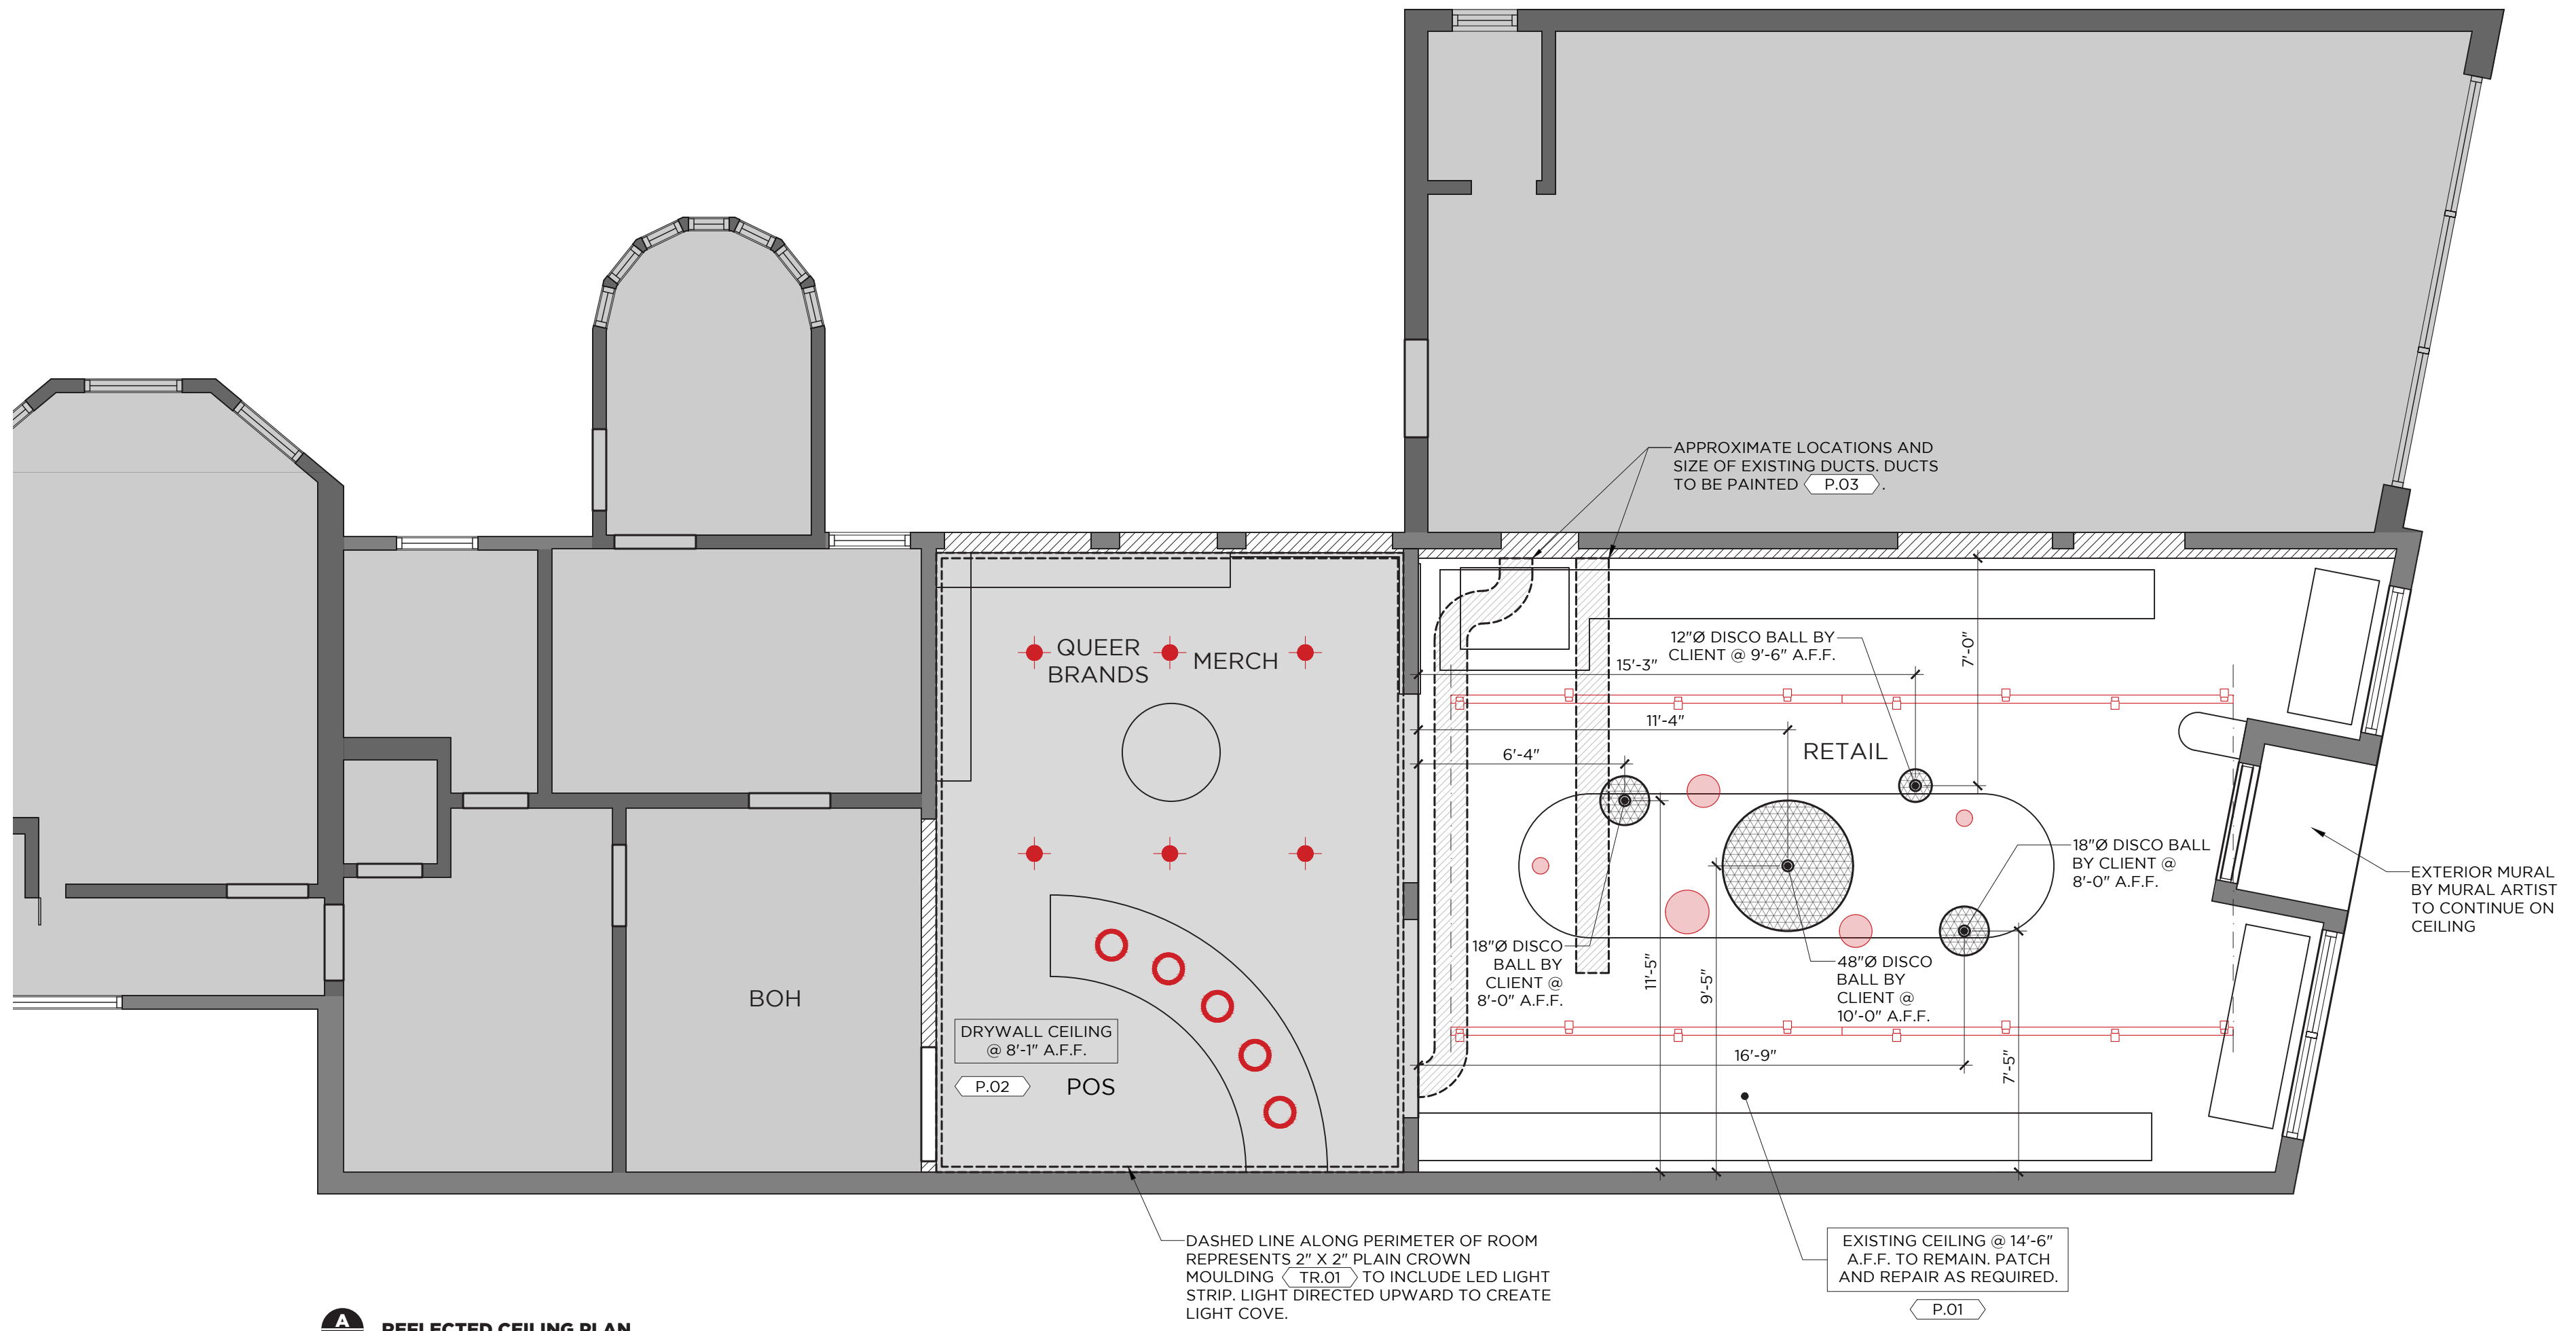

A REFLECTED CEILING PLAN

ALL IDEAS, DESIGNS, ARRANGEMENTS INDICATED ON THESE PROJECT DOCUMENTS ARE THE PROPERTY OF SEVENPOINT INTERIORS. DRAWINGS ARE FOR REFERENCE ONLY, ARE INTENDED TO BE USED WITH THIS SPECIFIC PROJECT, AND SHALL NOT OTHERWISE BE MODIFIED OR REPRODUCED FOR ANY PURPOSE WITHOUT THE WRITTEN AUTHORIZATION OF SEVENPOINT INTERIORS. SITE MEASURE IS REQUIRED BY TRADES PRIOR TO COMMENCING ANY WORK. DIMENSIONS ON DRAWINGS ARE ONLY APPROXIMATE. ALL VIEWS, DRAWINGS, DIAGRAMS ARE CONCEPTUAL AND MAY BE SUBJECT TO CHANGE. MATERIAL REFERENCE IMAGES ON SCREEN AND IN PRINT MAY DIFFER FROM ACTUAL PRODUCT. REFER TO PHYSICAL SAMPLE.

DESIGNED BY
SEVENPOINT INTERIORS

CONTACT
DESMOND@COFODESIGN.COM / JANE@COFODESIGN.COM

ADDRESS
21 REGINA ROAD, WOODBRIDGE, ONTARIO, CANADA, L4L 8L9

PROJECT
GREEN QWEEN - SHERMAN OAKS


CLIENT
TAYLOR BAZLEY / ANDRES RIGAL

ADDRESS
SHERMAN OAKS, CA

NO.	ISSUANCE	DATE	DRAWING TITLE								
4	MATERIALS REVIEW	JUN-13-2024	REFLECTED CEILING PLAN								
5	CLIENT REVIEW	JUN-21-2024									
6	CLIENT REVIEW [R1]	JUL-11-2024									
7	HR1	JUL-22-2024									
8	HR2	JUL-25-2024	<table border="1"> <tr> <td>SCALE</td> <td>N/A</td> <td rowspan="2">PAGE NO.</td> </tr> <tr> <td>RETAIL AREA</td> <td>795 SQFT</td> </tr> <tr> <td>PROPOSAL NO.</td> <td>XX-XXXX-XX</td> <td></td> </tr> </table>	SCALE	N/A	PAGE NO.	RETAIL AREA	795 SQFT	PROPOSAL NO.	XX-XXXX-XX	
SCALE	N/A	PAGE NO.									
RETAIL AREA	795 SQFT										
PROPOSAL NO.	XX-XXXX-XX										

GENERAL NOTES

G.C. TO SUPPLY AND INSTALL. ALL LIGHTING TO BE DIMMABLE IF AVAILABLE. ENSURE FIXTURES ARE COMPLETED WITH ALL NECESSARY COMPONENTS FOR INSTALLATION AND OPERATION. VERIFY WITH MANUFACTURERS' SPECIFICATIONS FOR POWER AND MOUNTING REQUIREMENTS. REFER TO INTERIOR DESIGN SCHEDULE AND DRAWINGS FOR DESIGN DIRECTION.

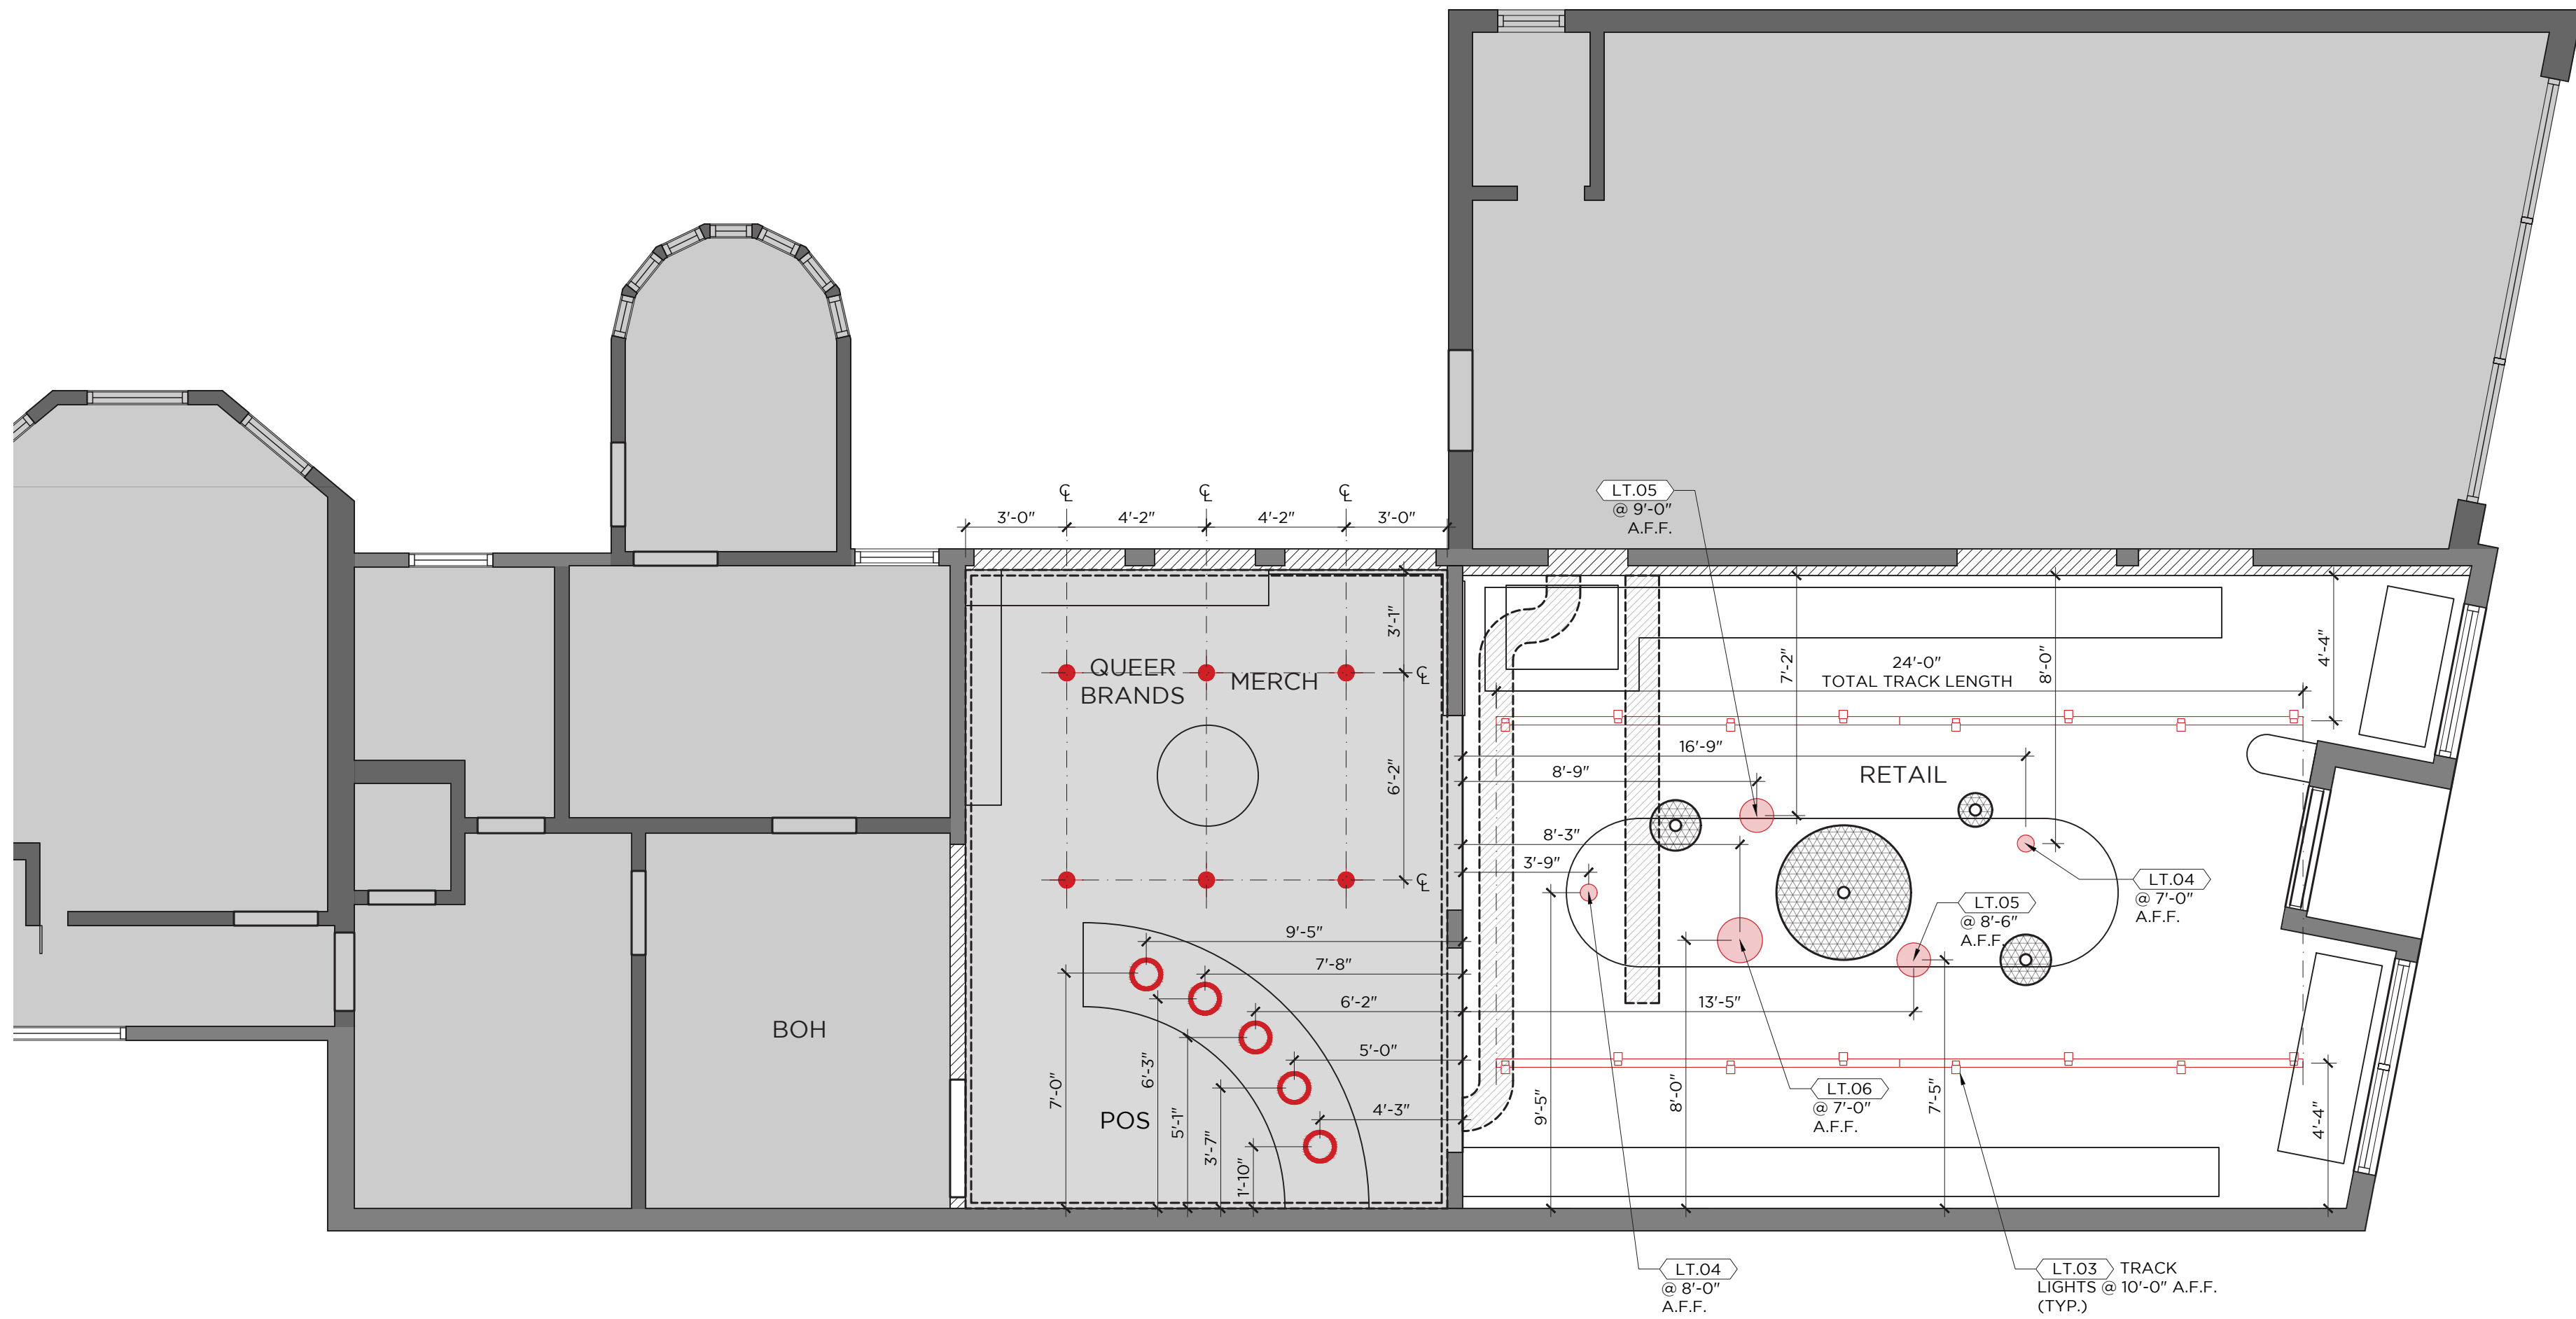

A LIGHTING PLAN

ALL IDEAS, DESIGNS, ARRANGEMENTS INDICATED ON THESE PROJECT DOCUMENTS ARE THE PROPERTY OF SEVENPOINT INTERIORS. DRAWINGS ARE FOR REFERENCE ONLY. ARE INTENDED TO BE USED WITH THIS SPECIFIC PROJECT. AND SHALL NOT OTHERWISE BE MODIFIED OR REPRODUCED FOR ANY PURPOSE WITHOUT THE WRITTEN AUTHORIZATION OF SEVENPOINT INTERIORS. SITE MEASURE IS REQUIRED BY TRADES PRIOR TO COMMENCING ANY WORK. DIMENSIONS ON DRAWINGS ARE ONLY APPROXIMATE. ALL VIEWS, DRAWINGS, DIAGRAMS ARE CONCEPTUAL AND MAY BE SUBJECT TO CHANGE. MATERIAL REFERENCE IMAGES ON SCREEN AND IN PRINT MAY DIFFER FROM ACTUAL PRODUCT. REFER TO PHYSICAL SAMPLE.

DESIGNED BY
SEVENPOINT INTERIORS

CONTACT
DESMOND@COFODESIGN.COM / JANE@COFODESIGN.COM

ADDRESS
21 REGINA ROAD, WOODBRIDGE, ONTARIO, CANADA, L4L 8L9

PROJECT
GREEN QWEEN - SHERMAN OAKS


CLIENT
TAYLOR BAZLEY / ANDRES RIGAL

ADDRESS
SHERMAN OAKS, CA

NO.	ISSUANCE	DATE	DRAWING TITLE											
4	MATERIALS REVIEW	JUN-13-2024	<table border="1"> <tr> <td>SCALE</td> <td>N/A</td> <td rowspan="2">PAGE NO.</td> </tr> <tr> <td>RETAIL AREA</td> <td>795 SQFT</td> </tr> <tr> <td>PROPOSAL NO.</td> <td>XX-XXXX-XX</td> <td rowspan="2"> <p style="font-size: 2em; font-weight: bold;">10</p> </td> </tr> <tr> <td colspan="2"></td> </tr> </table>		SCALE	N/A	PAGE NO.	RETAIL AREA	795 SQFT	PROPOSAL NO.	XX-XXXX-XX	<p style="font-size: 2em; font-weight: bold;">10</p>		
SCALE	N/A	PAGE NO.												
RETAIL AREA	795 SQFT													
PROPOSAL NO.	XX-XXXX-XX	<p style="font-size: 2em; font-weight: bold;">10</p>												
5	CLIENT REVIEW	JUN-21-2024												
6	CLIENT REVIEW [R1]	JUL-11-2024												
7	HR1	JUL-22-2024												
8	HR2	JUL-25-2024												


GENERAL NOTES

G.C. TO SUPPLY AND INSTALL. USE WHITE SCREWLESS COVER PLATES FOR ALL OUTLETS. ALL WALL OUTLETS TO BE 18" A.F.F. UNLESS NOTED OTHERWISE. ALL CABLE MANAGEMENT TO BE CONCEALED. REFER TO ARCHITECTURAL DRAWINGS FOR MORE INFORMATION.

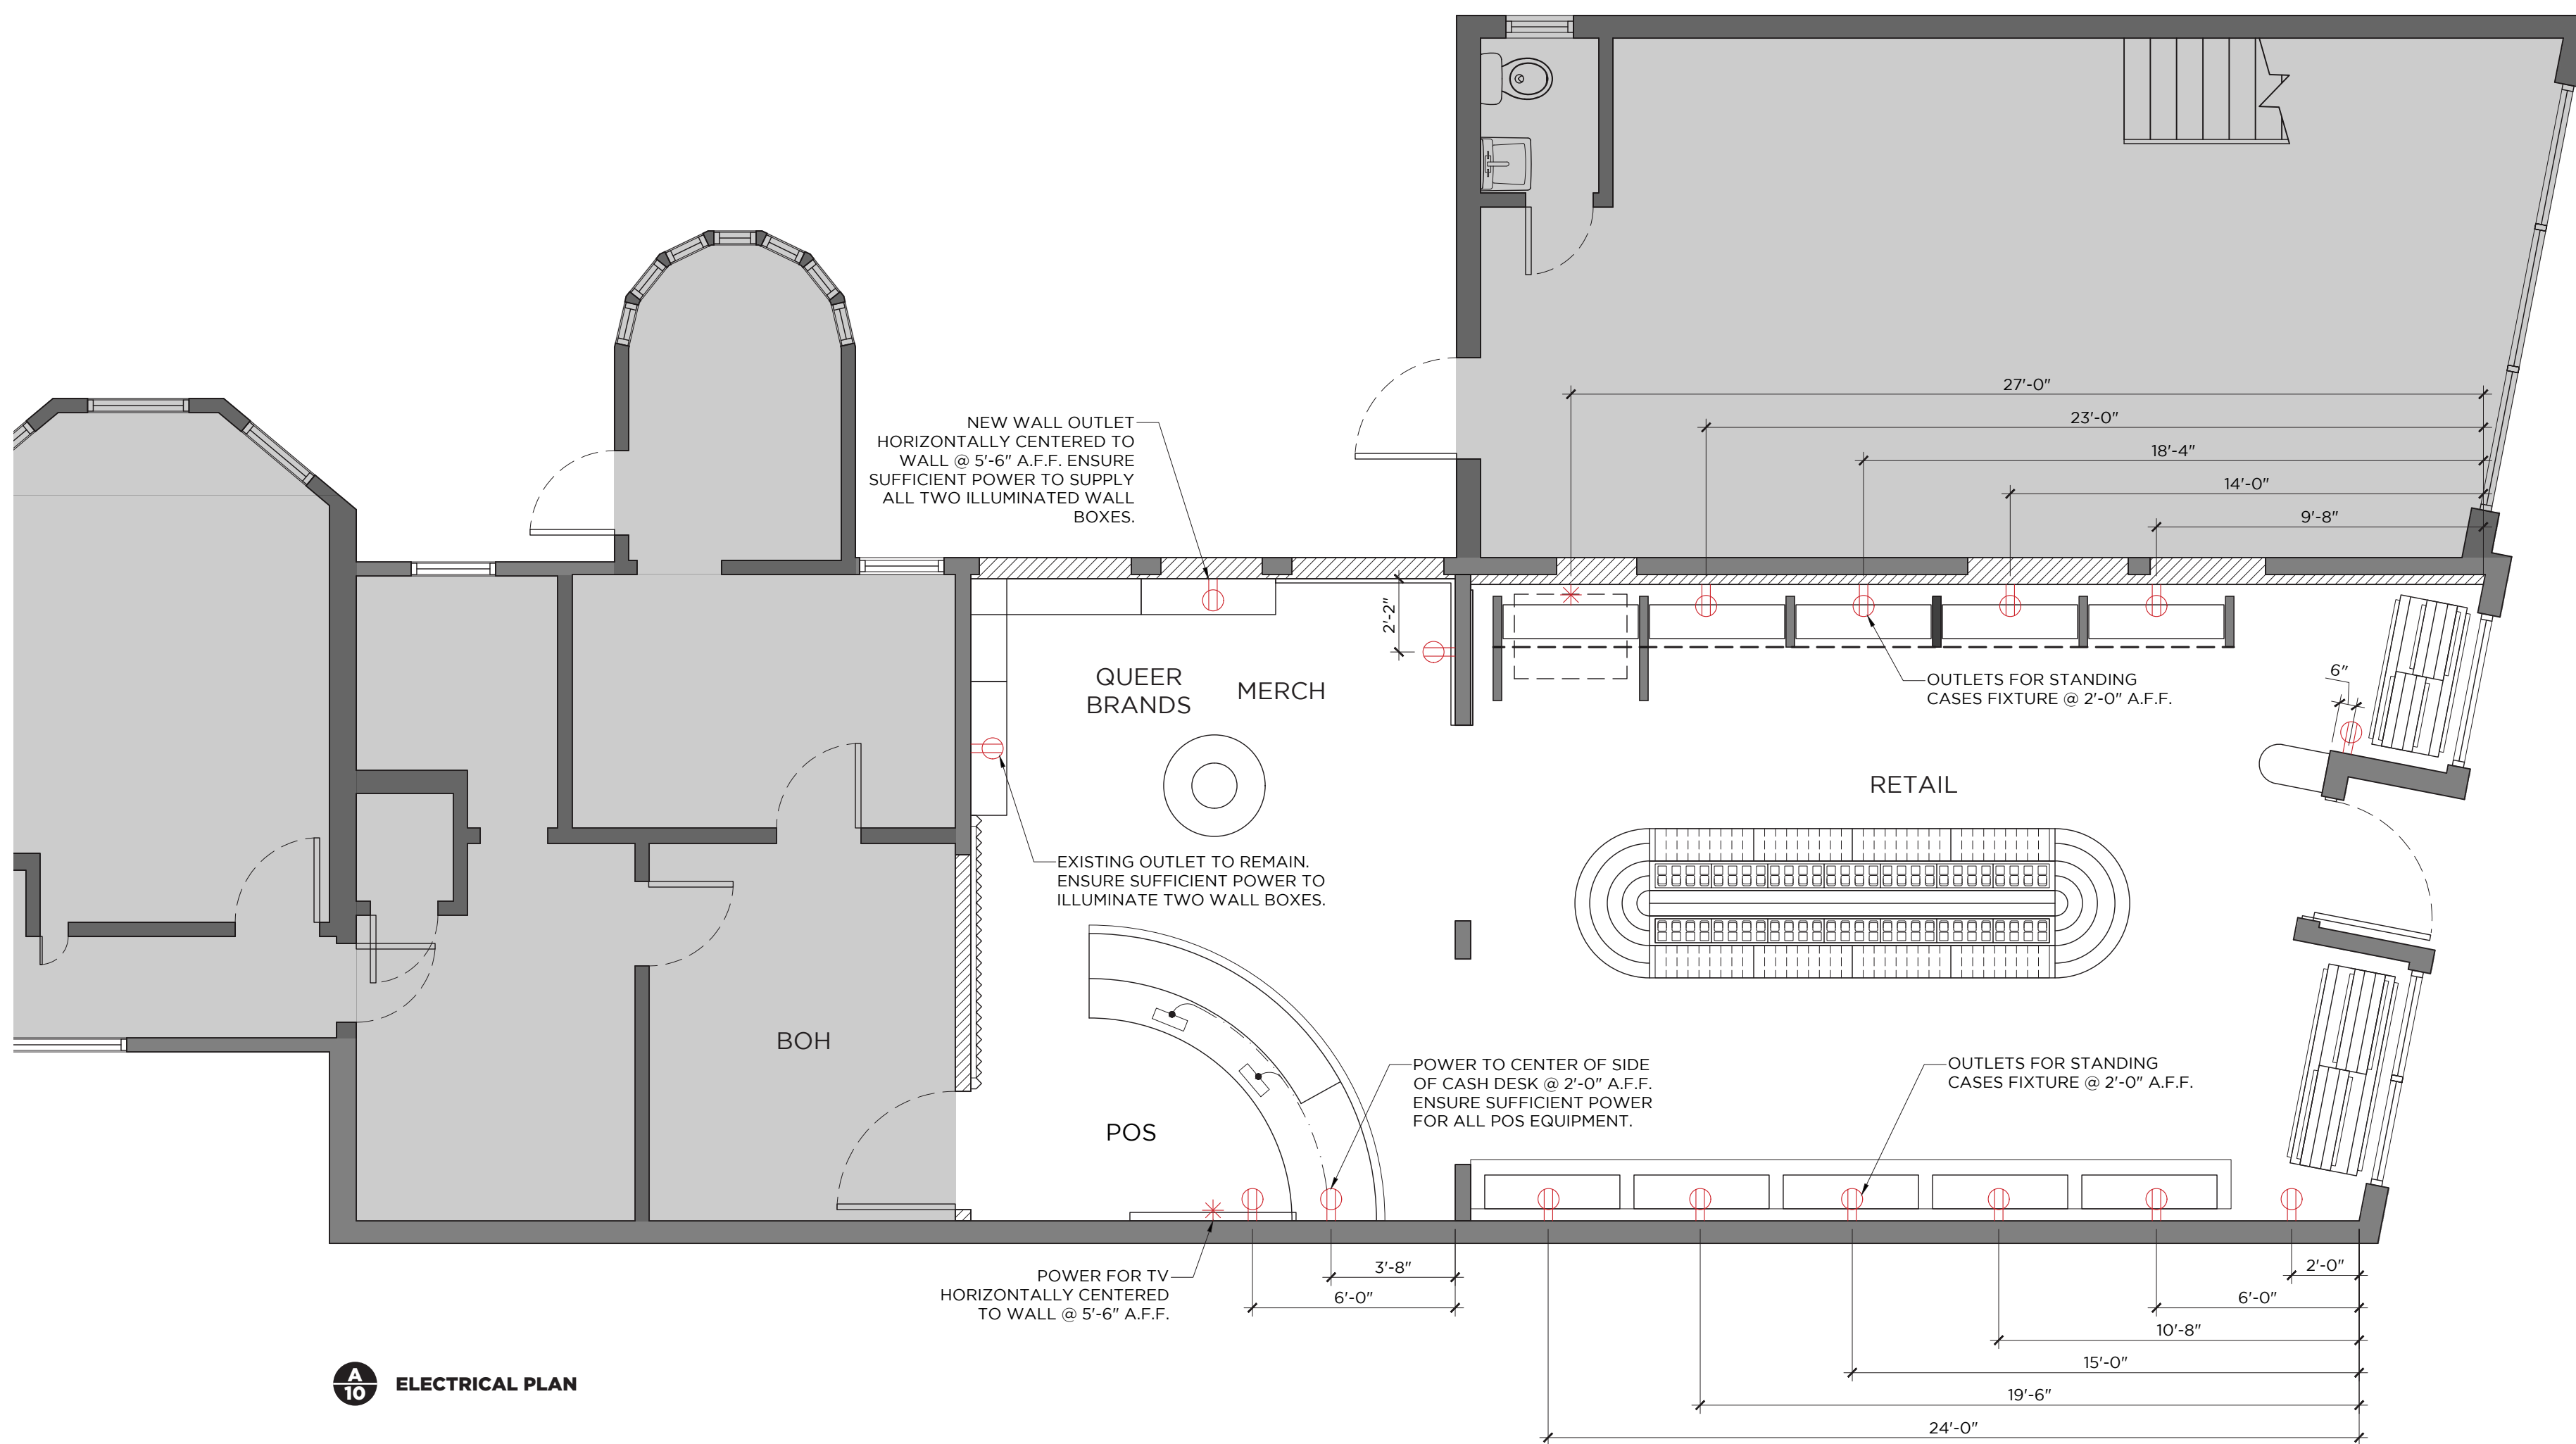

A
10 ELECTRICAL PLAN

ALL IDEAS, DESIGNS, ARRANGEMENTS INDICATED ON THESE PROJECT DOCUMENTS ARE THE PROPERTY OF SEVENPOINT INTERIORS. DRAWINGS ARE FOR REFERENCE ONLY. ARE INTENDED TO BE USED WITH THIS SPECIFIC PROJECT, AND SHALL NOT OTHERWISE BE MODIFIED OR REPRODUCED FOR ANY PURPOSE WITHOUT THE WRITTEN AUTHORIZATION OF SEVENPOINT INTERIORS. SITE MEASURE IS REQUIRED BY TRADES PRIOR TO COMMENCING ANY WORK. DIMENSIONS ON DRAWINGS ARE ONLY APPROXIMATE. ALL VIEWS, DRAWINGS, DIAGRAMS ARE CONCEPTUAL AND MAY BE SUBJECT TO CHANGE. MATERIAL REFERENCE IMAGES ON SCREEN AND IN PRINT MAY DIFFER FROM ACTUAL PRODUCT. REFER TO PHYSICAL SAMPLE.

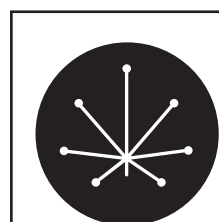

DESIGNED BY
SEVENPOINT INTERIORS

CONTACT
DESMOND@COFODESIGN.COM / JANE@COFODESIGN.COM

ADDRESS
21 REGINA ROAD, WOODBRIDGE, ONTARIO, CANADA, L4L 8L9




PROJECT
GREEN QWEEN - SHERMAN OAKS

CLIENT
TAYLOR BAZLEY / ANDRES RIGAL



ADDRESS
SHERMAN OAKS, CA

NO.	ISSUANCE	DATE	DRAWING TITLE		
4	MATERIALS REVIEW	JUN-13-2024	ELECTRICAL PLAN		
5	CLIENT REVIEW	JUN-21-2024			
6	CLIENT REVIEW [R1]	JUL-11-2024			
7	HR1	JUL-22-2024			
8	HR2	JUL-25-2024	SCALE	N/A	PAGE NO.
			RETAIL AREA	795 SQFT	
			PROPOSAL NO.	XX-XXXX-XX	11

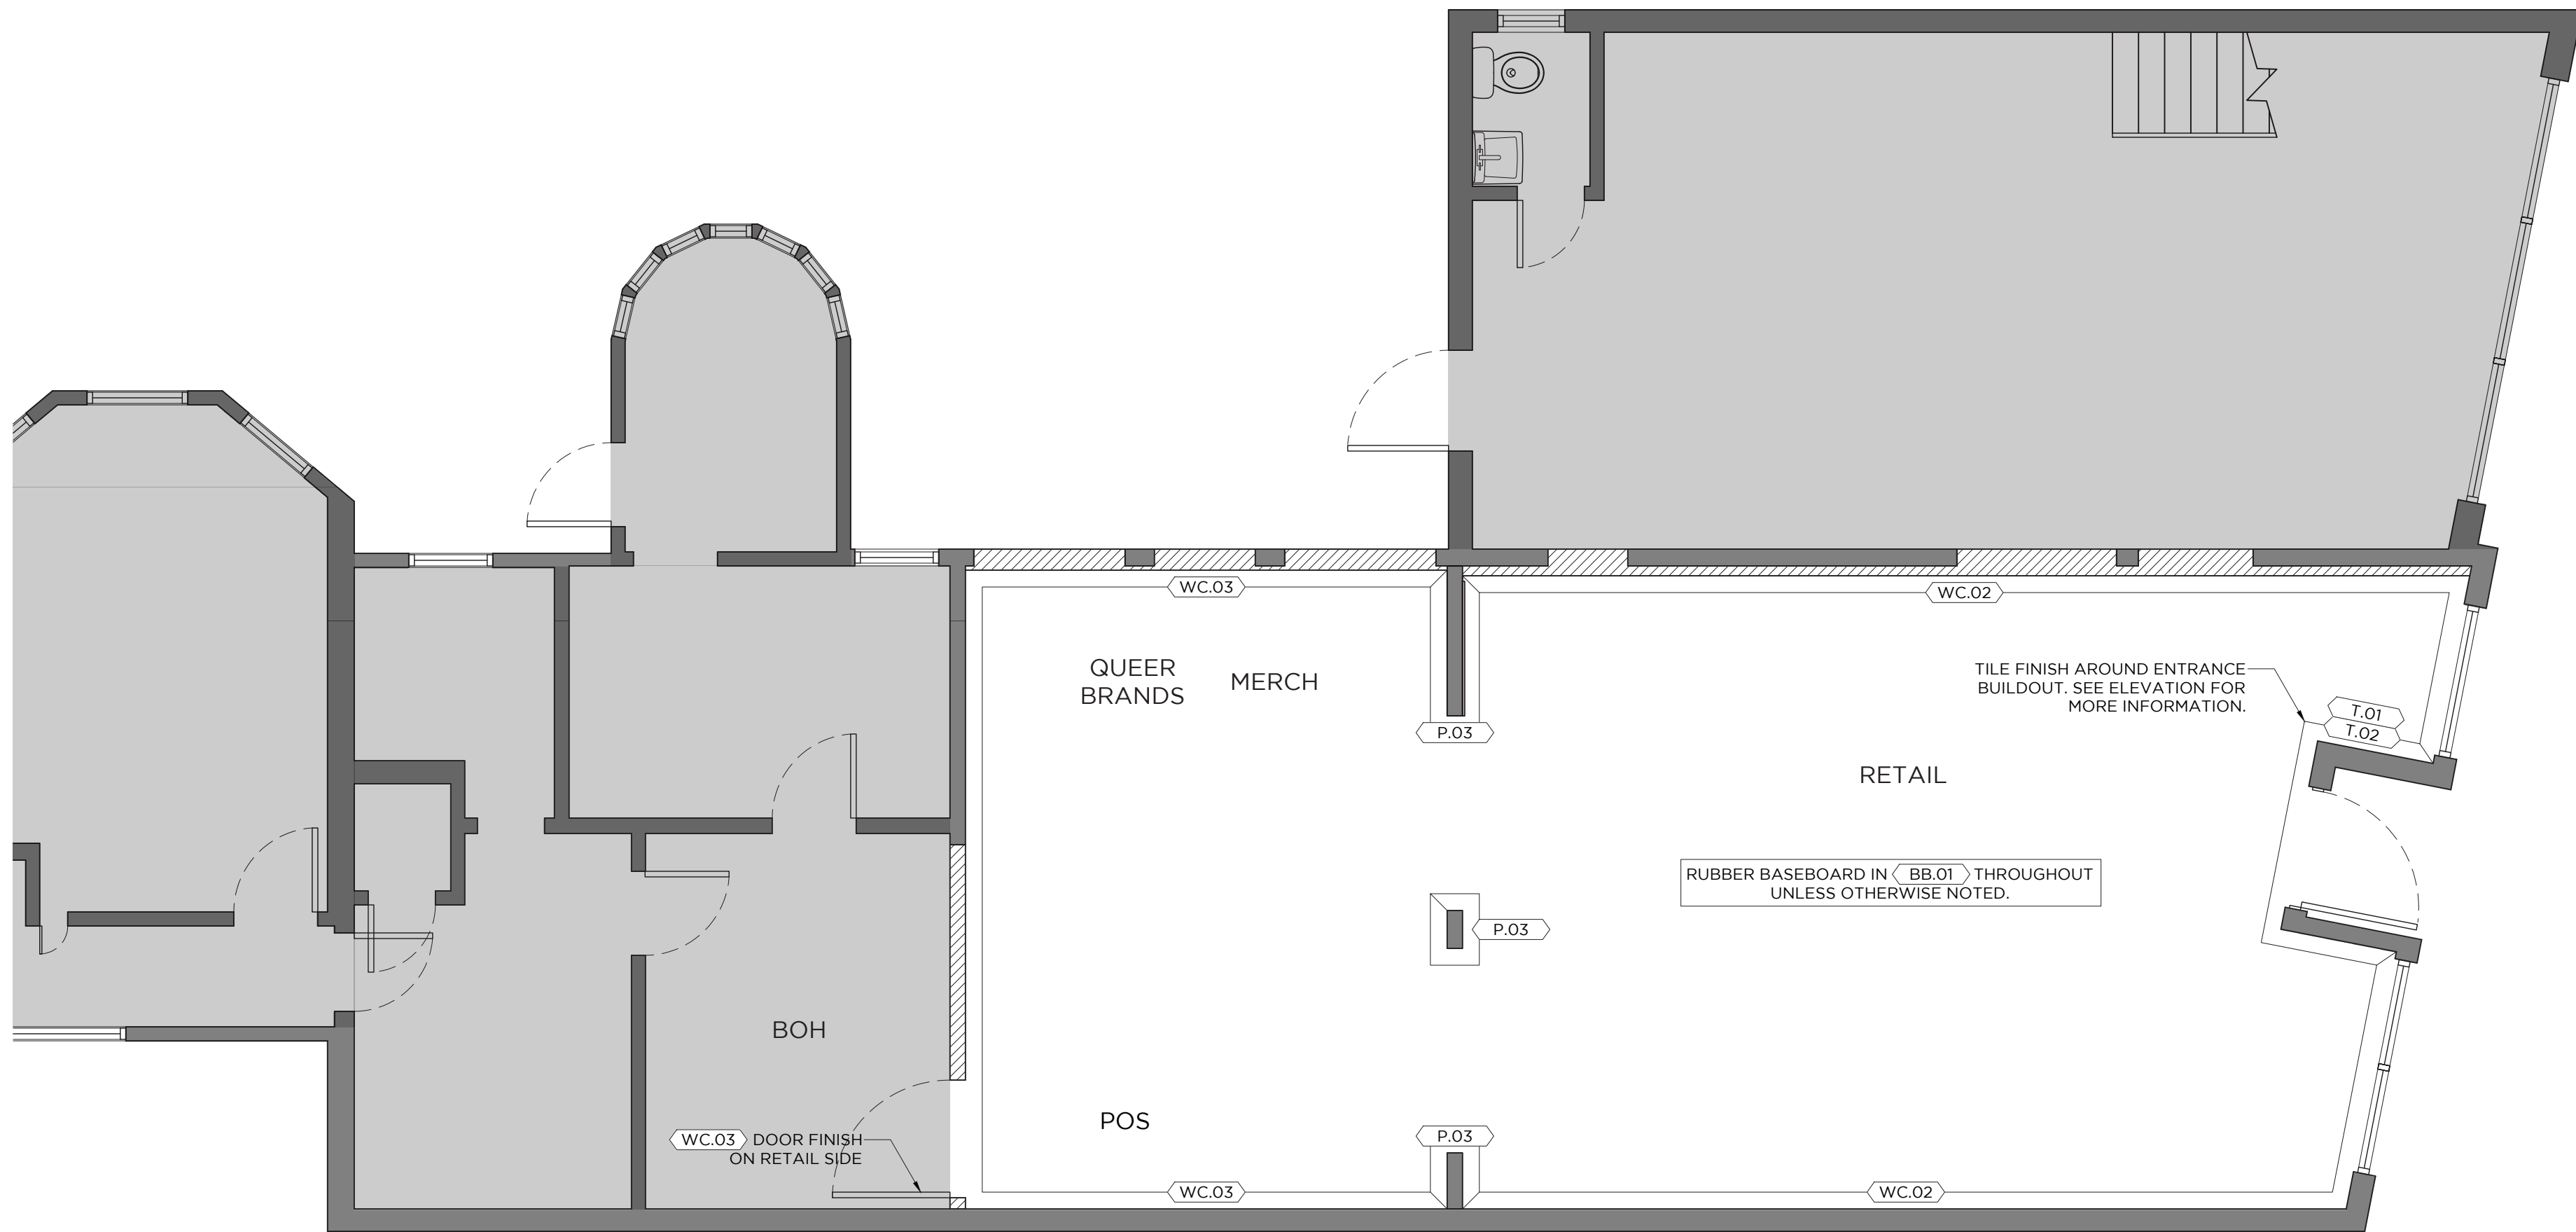


A
11 WALL FINISH PLAN

ALL IDEAS, DESIGNS, ARRANGEMENTS INDICATED ON THESE PROJECT DOCUMENTS ARE THE PROPERTY OF SEVENPOINT INTERIORS. DRAWINGS ARE FOR REFERENCE ONLY, ARE INTENDED TO BE USED WITH THIS SPECIFIC PROJECT, AND SHALL NOT OTHERWISE BE MODIFIED OR REPRODUCED FOR ANY PURPOSE WITHOUT THE WRITTEN AUTHORIZATION OF SEVENPOINT INTERIORS. SITE MEASURE IS REQUIRED BY TRADES PRIOR TO COMMENCING ANY WORK. DIMENSIONS ON DRAWINGS ARE ONLY APPROXIMATE. ALL VIEWS, DRAWINGS, DIAGRAMS ARE CONCEPTUAL AND MAY BE SUBJECT TO CHANGE. MATERIAL REFERENCE IMAGES ON SCREEN AND IN PRINT MAY DIFFER FROM ACTUAL PRODUCT. REFER TO PHYSICAL SAMPLE.

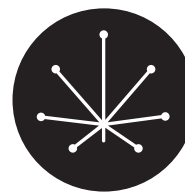	DESIGNED BY SEVENPOINT INTERIORS		PROJECT GREEN QWEEN - SHERMAN OAKS	NO.	ISSUANCE	DATE	DRAWING TITLE	
	CONTACT DESMOND@COFODESIGN.COM / JANE@COFODESIGN.COM		CLIENT TAYLOR BAZLEY / ANDRES RIGAL	4	MATERIALS REVIEW	JUN-13-2024	SCALE N/A RETAIL AREA 795 SQFT PROPOSAL NO. XX-XXXX-XX	PAGE NO. 12
	ADDRESS 21 REGINA ROAD, WOODBRIDGE, ONTARIO, CANADA, L4L 8L9		ADDRESS SHERMAN OAKS, CA	5	CLIENT REVIEW	JUN-21-2024		
				6	CLIENT REVIEW [R1]	JUL-11-2024		
		7	HR1	JUL-22-2024				
				8	HR2	JUL-25-2024		


GENERAL NOTES

G.C. TO ENSURE SMOOTH TRANSITIONS BETWEEN ALL FLOOR FINISHES. USE TRANSITION STRIPS AS REQUIRED.

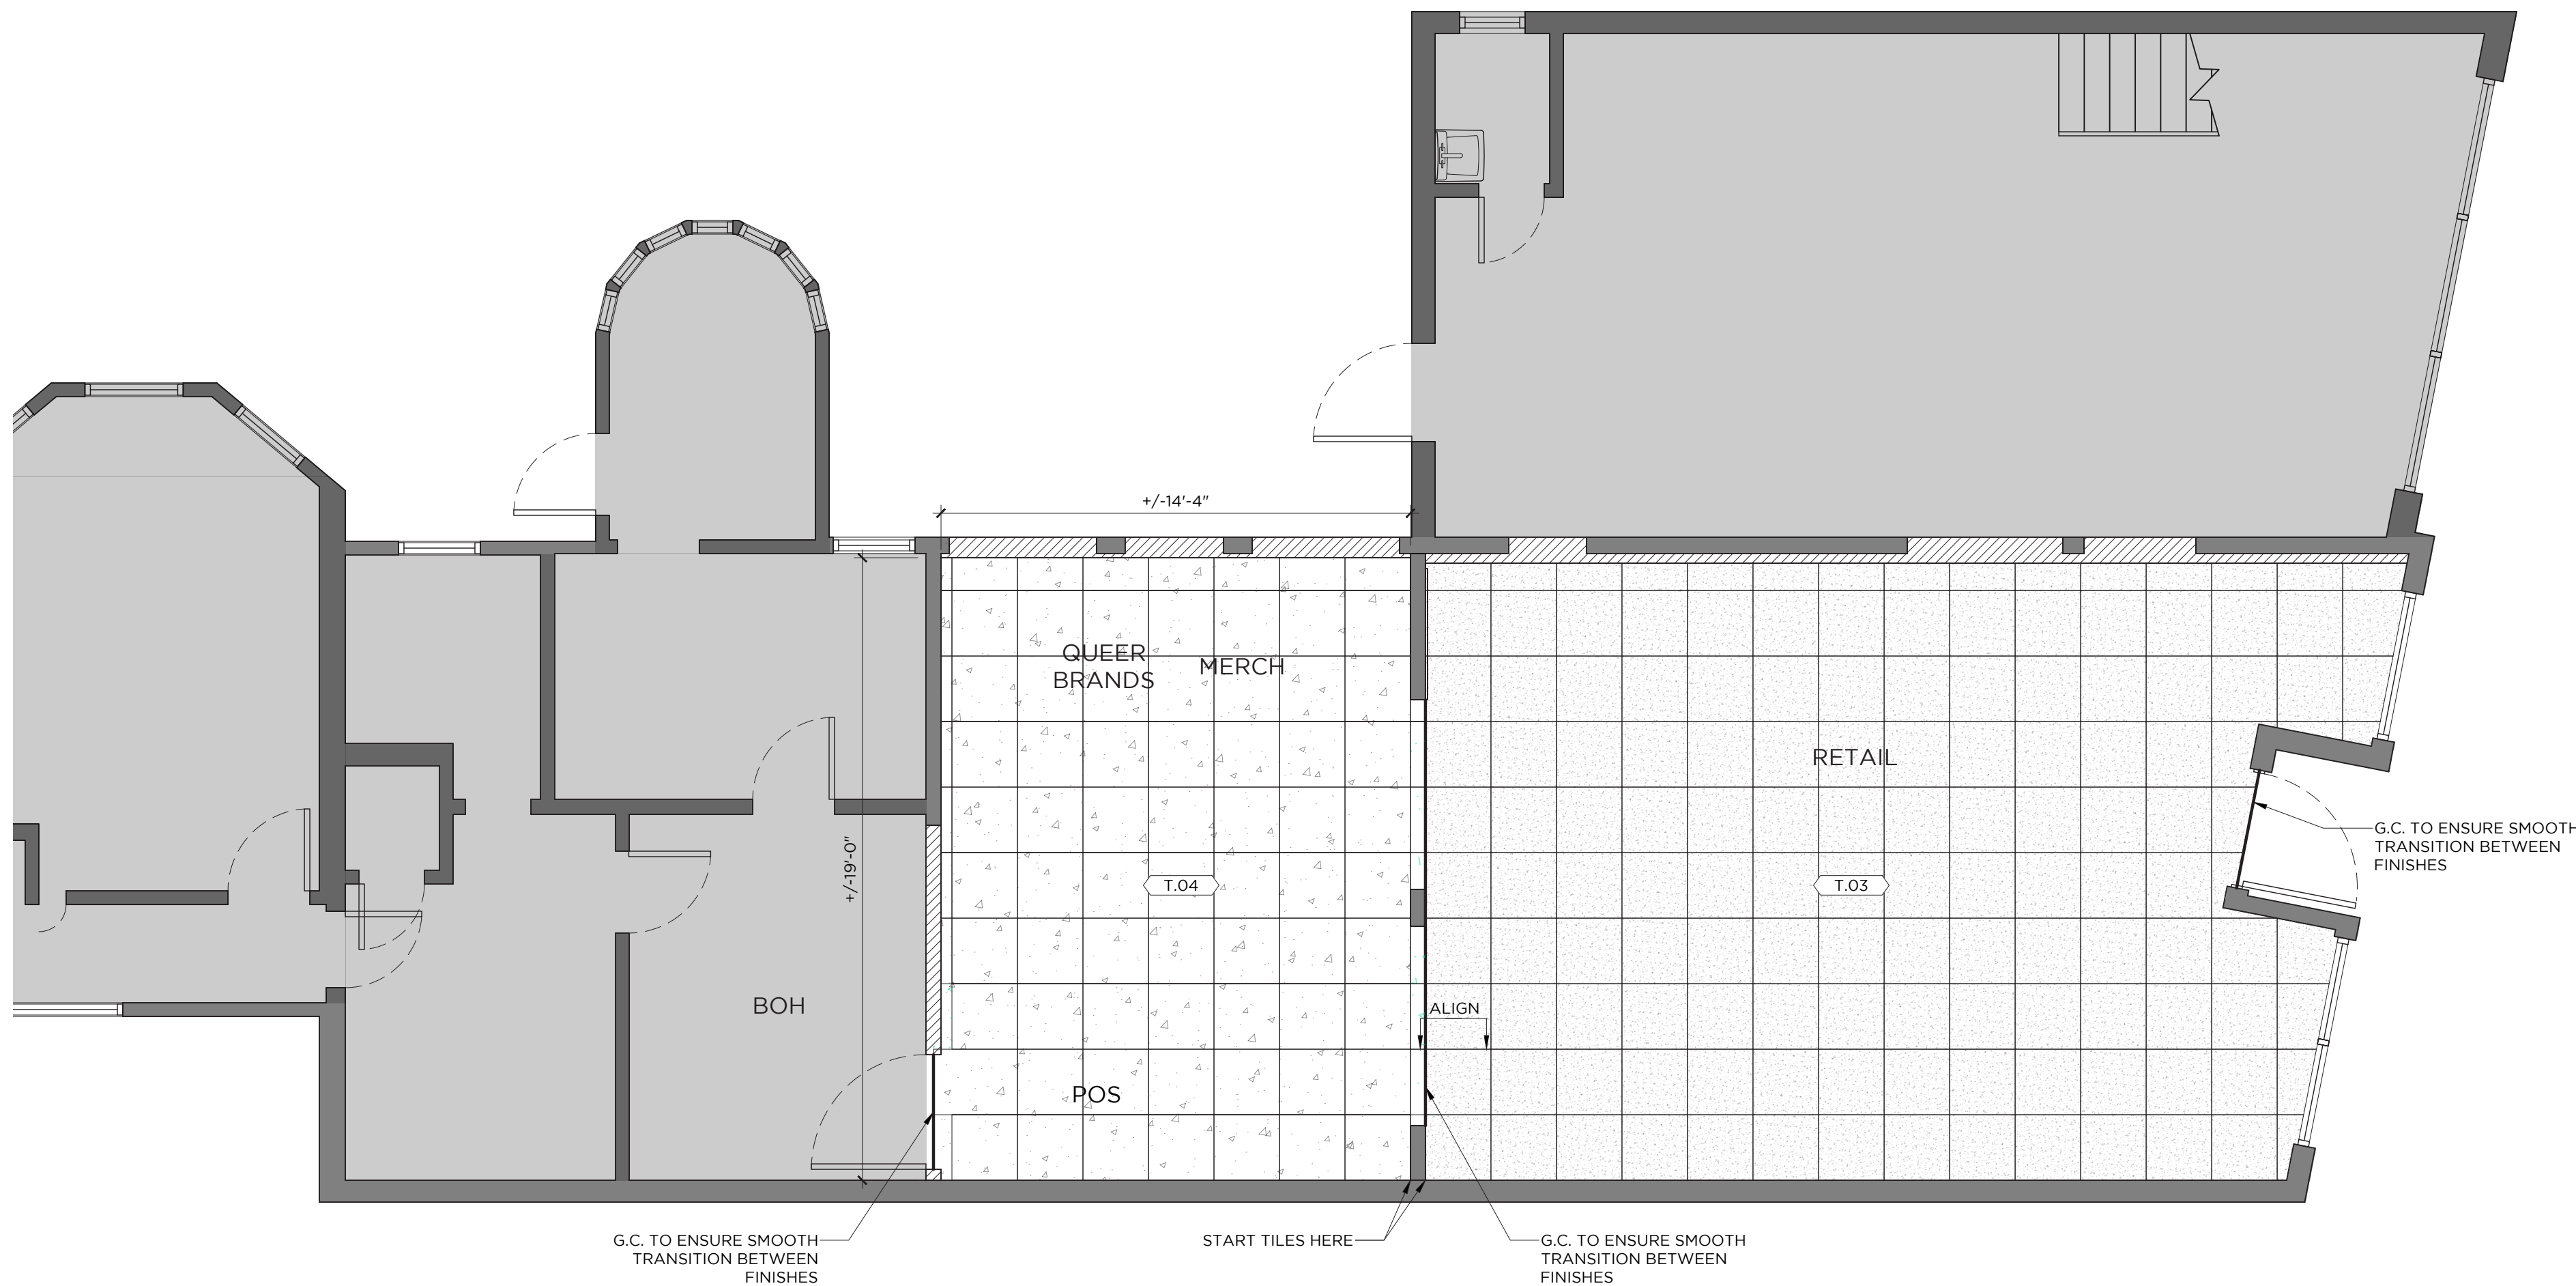

A
12 FLOOR FINISH PLAN

ALL IDEAS, DESIGNS, ARRANGEMENTS INDICATED ON THESE PROJECT DOCUMENTS ARE THE PROPERTY OF SEVENPOINT INTERIORS. DRAWINGS ARE FOR REFERENCE ONLY, ARE INTENDED TO BE USED WITH THIS SPECIFIC PROJECT, AND SHALL NOT OTHERWISE BE MODIFIED OR REPRODUCED FOR ANY PURPOSE WITHOUT THE WRITTEN AUTHORIZATION OF SEVENPOINT INTERIORS. SITE MEASURE IS REQUIRED BY TRADES PRIOR TO COMMENCING ANY WORK. DIMENSIONS ON DRAWINGS ARE ONLY APPROXIMATE. ALL VIEWS, DRAWINGS, DIAGRAMS ARE CONCEPTUAL AND MAY BE SUBJECT TO CHANGE. MATERIAL REFERENCE IMAGES ON SCREEN AND IN PRINT MAY DIFFER FROM ACTUAL PRODUCT. REFER TO PHYSICAL SAMPLE.

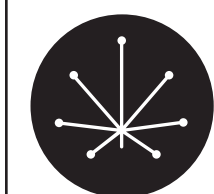

DESIGNED BY
SEVENPOINT INTERIORS

CONTACT
DESMOND@COFODESIGN.COM / JANE@COFODESIGN.COM

ADDRESS
21 REGINA ROAD, WOODBRIDGE, ONTARIO, CANADA, L4L 8L9




PROJECT
GREEN QWEEN - SHERMAN OAKS

CLIENT
TAYLOR BAZLEY / ANDRES RIGAL

ADDRESS
SHERMAN OAKS, CA

NO.	ISSUANCE	DATE	DRAWING TITLE	
4	MATERIALS REVIEW	JUN-13-2024	FLOOR FINISH PLAN SCALE N/A RETAIL AREA 795 SQFT PROPOSAL NO. XX-XXXX-XX PAGE NO. 13	
5	CLIENT REVIEW	JUN-21-2024		
6	CLIENT REVIEW [R1]	JUL-11-2024		
7	HR1	JUL-22-2024		
8	HR2	JUL-25-2024		

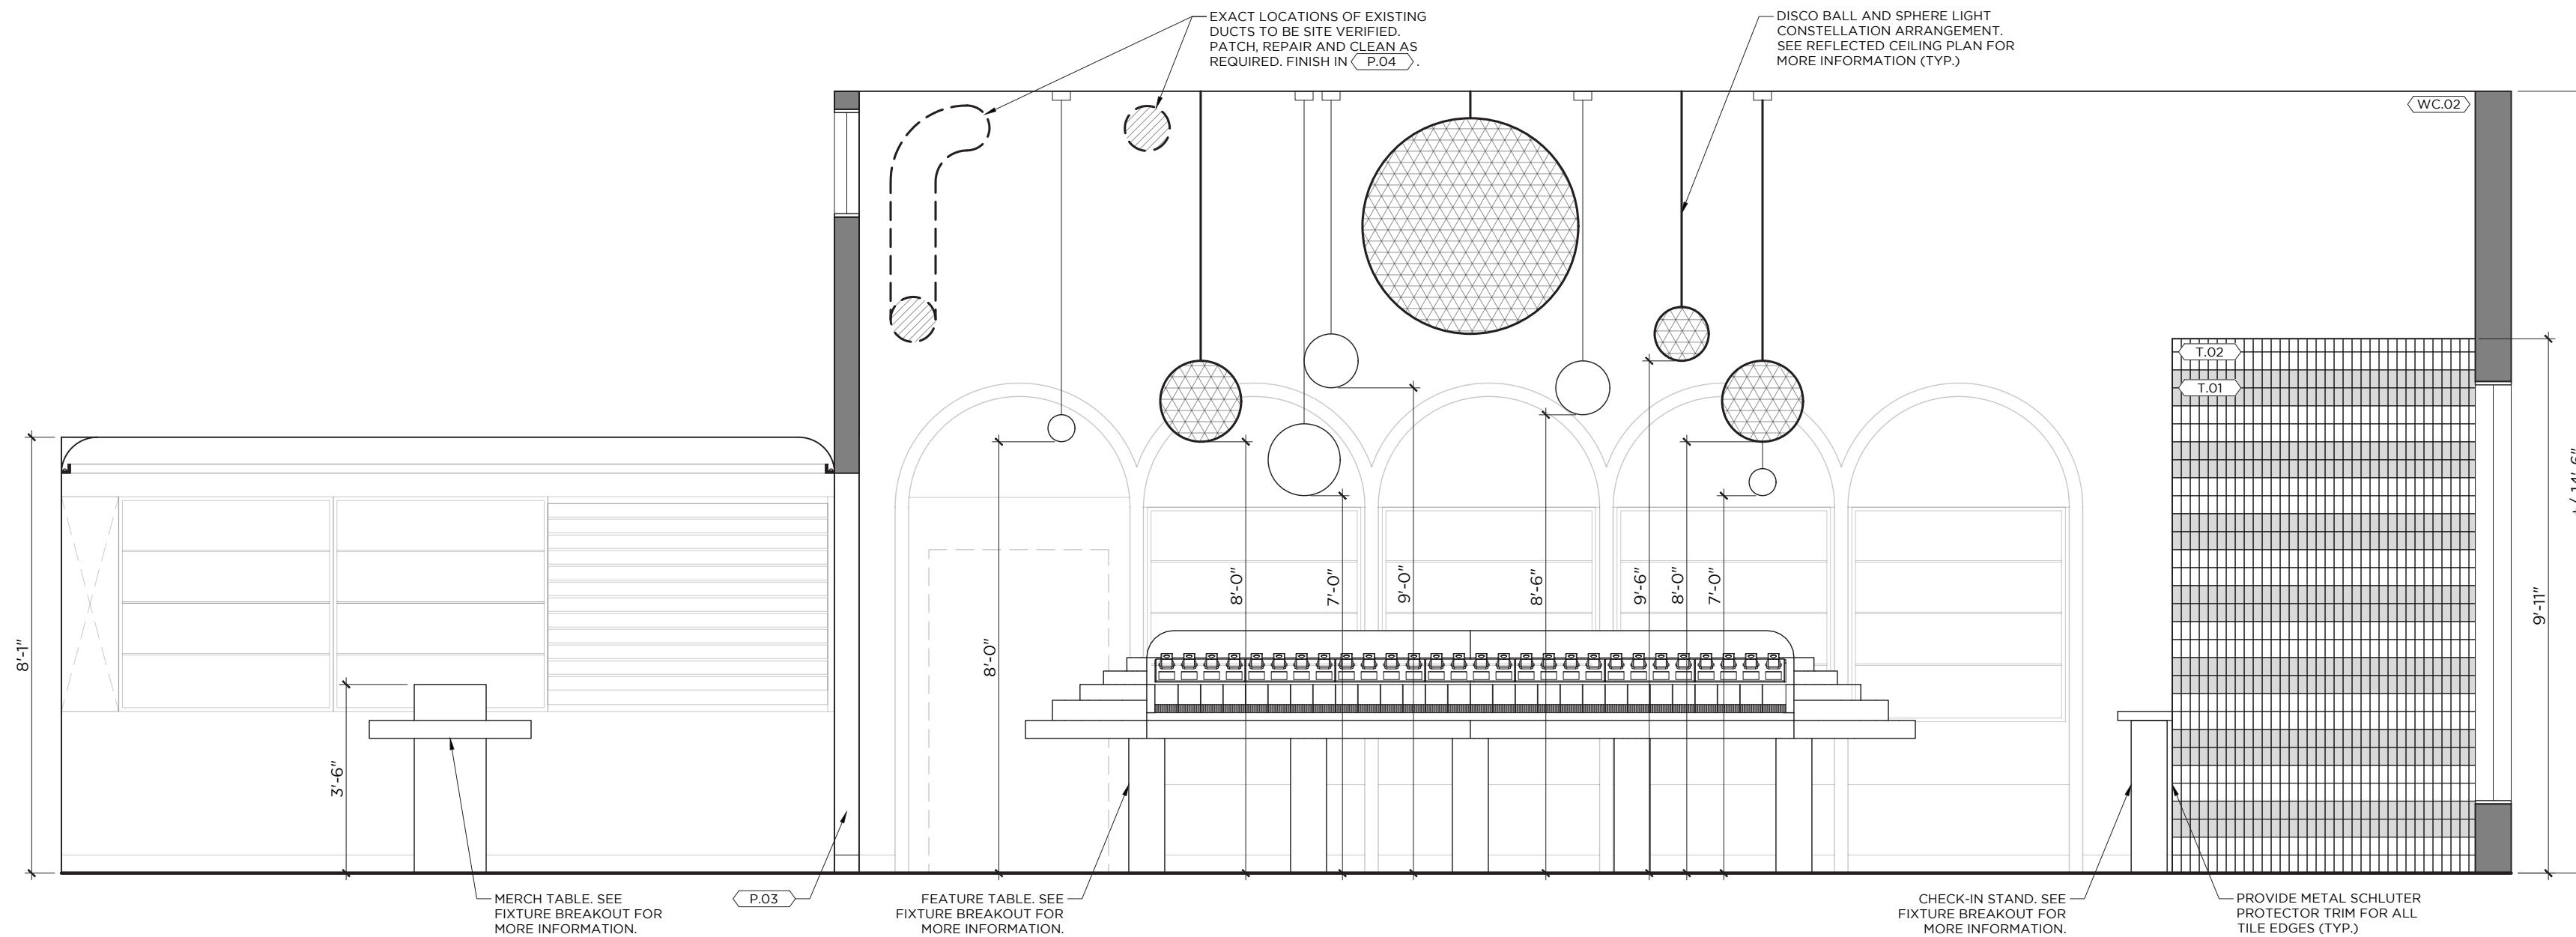

A
16 RETAIL - TOWARD FEATURE TABLE


ALL IDEAS, DESIGNS, ARRANGEMENTS INDICATED ON THESE PROJECT DOCUMENTS ARE THE PROPERTY OF SEVENPOINT INTERIORS. DRAWINGS ARE FOR REFERENCE ONLY, ARE INTENDED TO BE USED WITH THIS SPECIFIC PROJECT, AND SHALL NOT OTHERWISE BE MODIFIED OR REPRODUCED FOR ANY PURPOSE WITHOUT THE WRITTEN AUTHORIZATION OF SEVENPOINT INTERIORS. SITE MEASURE IS REQUIRED BY TRADES PRIOR TO COMMENCING ANY WORK. DIMENSIONS ON DRAWINGS ARE ONLY APPROXIMATE. ALL VIEWS, DRAWINGS, DIAGRAMS ARE CONCEPTUAL AND MAY BE SUBJECT TO CHANGE. MATERIAL REFERENCE IMAGES ON SCREEN AND IN PRINT MAY DIFFER FROM ACTUAL PRODUCT. REFER TO PHYSICAL SAMPLE.



DESIGNED BY
SEVENPOINT INTERIORS

CONTACT
DESMOND@COFODESIGN.COM / JANE@COFODESIGN.COM

ADDRESS
21 REGINA ROAD, WOODBRIDGE, ONTARIO, CANADA, L4L 8L9



PROJECT
GREEN QWEEN - SHERMAN OAKS

CLIENT
TAYLOR BAZLEY / ANDRES RIGAL

ADDRESS
SHERMAN OAKS, CA


NO.	ISSUANCE	DATE	DRAWING TITLE	
4	MATERIALS REVIEW	JUN-13-2024		
5	CLIENT REVIEW	JUN-21-2024		
6	CLIENT REVIEW [R1]	JUL-11-2024	SCALE	N/A
7	HR1	JUL-22-2024	RETAIL AREA	795 SQFT
8	HR2	JUL-25-2024	PROPOSAL NO.	XX-XXXX-XX

ELEVATIONS
18

PAGE NO.



ALL IDEAS, DESIGNS, ARRANGEMENTS INDICATED ON THESE PROJECT DOCUMENTS ARE THE PROPERTY OF SEVENPOINT INTERIORS. DRAWINGS ARE FOR REFERENCE ONLY, ARE INTENDED TO BE USED WITH THIS SPECIFIC PROJECT, AND SHALL NOT OTHERWISE BE MODIFIED OR REPRODUCED FOR ANY PURPOSE WITHOUT THE WRITTEN AUTHORIZATION OF SEVENPOINT INTERIORS. SITE MEASURE IS REQUIRED BY TRADES PRIOR TO COMMENCING ANY WORK. DIMENSIONS ON DRAWINGS ARE ONLY APPROXIMATE. ALL VIEWS, DRAWINGS, DIAGRAMS ARE CONCEPTUAL AND MAY BE SUBJECT TO CHANGE. MATERIAL REFERENCE IMAGES ON SCREEN AND IN PRINT MAY DIFFER FROM ACTUAL PRODUCT. REFER TO PHYSICAL SAMPLE.

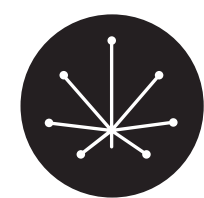

DESIGNED BY
SEVENPOINT INTERIORS

CONTACT
DESMOND@COFODESIGN.COM / JANE@COFODESIGN.COM

ADDRESS
21 REGINA ROAD, WOODBRIDGE, ONTARIO, CANADA, L4L 8L9



PROJECT
GREEN QWEEN - SHERMAN OAKS


CLIENT
TAYLOR BAZLEY / ANDRES RIGAL

ADDRESS
SHERMAN OAKS, CA

NO.	ISSUANCE	DATE	DRAWING TITLE		
4	MATERIALS REVIEW	JUN-13-2024	HIGH-RES RENDERING		
5	CLIENT REVIEW	JUN-21-2024			
6	CLIENT REVIEW [R1]	JUL-11-2024			
7	HR1	JUL-22-2024			
8	HR2	JUL-25-2024	SCALE	N/A	PAGE NO.
			RETAIL AREA	795 SQFT	19
			PROPOSAL NO.	XX-XXXX-XX	



ALL IDEAS, DESIGNS, ARRANGEMENTS INDICATED ON THESE PROJECT DOCUMENTS ARE THE PROPERTY OF SEVENPOINT INTERIORS. DRAWINGS ARE FOR REFERENCE ONLY, ARE INTENDED TO BE USED WITH THIS SPECIFIC PROJECT, AND SHALL NOT OTHERWISE BE MODIFIED OR REPRODUCED FOR ANY PURPOSE WITHOUT THE WRITTEN AUTHORIZATION OF SEVENPOINT INTERIORS. SITE MEASURE IS REQUIRED BY TRADES PRIOR TO COMMENCING ANY WORK. DIMENSIONS ON DRAWINGS ARE ONLY APPROXIMATE. ALL VIEWS, DRAWINGS, DIAGRAMS ARE CONCEPTUAL AND MAY BE SUBJECT TO CHANGE. MATERIAL REFERENCE IMAGES ON SCREEN AND IN PRINT MAY DIFFER FROM ACTUAL PRODUCT. REFER TO PHYSICAL SAMPLE.

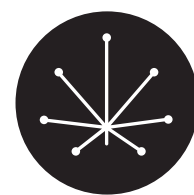

DESIGNED BY
SEVENPOINT INTERIORS

CONTACT
DESMOND@COFODESIGN.COM / JANE@COFODESIGN.COM

ADDRESS
21 REGINA ROAD, WOODBRIDGE, ONTARIO, CANADA, L4L 8L9



PROJECT
GREEN QWEEN - SHERMAN OAKS


CLIENT
TAYLOR BAZLEY / ANDRES RIGAL

ADDRESS
SHERMAN OAKS, CA

NO.	ISSUANCE	DATE	DRAWING TITLE		
4	MATERIALS REVIEW	JUN-13-2024	HIGH-RES RENDERING		
5	CLIENT REVIEW	JUN-21-2024			
6	CLIENT REVIEW [R1]	JUL-11-2024			
7	HR1	JUL-22-2024			
8	HR2	JUL-25-2024	SCALE	N/A	PAGE NO. 20
		RETAIL AREA	795 SQFT		
		PROPOSAL NO.	XX-XXXX-XX		



ALL IDEAS, DESIGNS, ARRANGEMENTS INDICATED ON THESE PROJECT DOCUMENTS ARE THE PROPERTY OF SEVENPOINT INTERIORS. DRAWINGS ARE FOR REFERENCE ONLY, ARE INTENDED TO BE USED WITH THIS SPECIFIC PROJECT, AND SHALL NOT OTHERWISE BE MODIFIED OR REPRODUCED FOR ANY PURPOSE WITHOUT THE WRITTEN AUTHORIZATION OF SEVENPOINT INTERIORS. SITE MEASURE IS REQUIRED BY TRADES PRIOR TO COMMENCING ANY WORK. DIMENSIONS ON DRAWINGS ARE ONLY APPROXIMATE. ALL VIEWS, DRAWINGS, DIAGRAMS ARE CONCEPTUAL AND MAY BE SUBJECT TO CHANGE. MATERIAL REFERENCE IMAGES ON SCREEN AND IN PRINT MAY DIFFER FROM ACTUAL PRODUCT. REFER TO PHYSICAL SAMPLE.

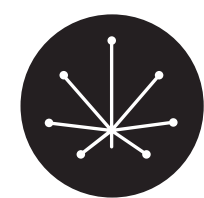

DESIGNED BY
SEVENPOINT INTERIORS

CONTACT
DESMOND@COFODESIGN.COM / JANE@COFODESIGN.COM

ADDRESS
21 REGINA ROAD, WOODBRIDGE, ONTARIO, CANADA, L4L 8L9



PROJECT
GREEN QWEEN - SHERMAN OAKS


CLIENT
TAYLOR BAZLEY / ANDRES RIGAL

ADDRESS
SHERMAN OAKS, CA

NO.	ISSUANCE	DATE	DRAWING TITLE									
4	MATERIALS REVIEW	JUN-13-2024	HIGH-RES RENDERING <table border="1" style="margin-left: auto; margin-right: auto;"> <tr> <td>SCALE</td> <td>N/A</td> <td>PAGE NO.</td> </tr> <tr> <td>RETAIL AREA</td> <td>795 SQFT</td> <td rowspan="2" style="font-size: 2em; font-weight: bold;">21</td> </tr> <tr> <td>PROPOSAL NO.</td> <td>XX-XXXX-XX</td> </tr> </table>		SCALE	N/A	PAGE NO.	RETAIL AREA	795 SQFT	21	PROPOSAL NO.	XX-XXXX-XX
SCALE	N/A	PAGE NO.										
RETAIL AREA	795 SQFT	21										
PROPOSAL NO.	XX-XXXX-XX											
5	CLIENT REVIEW	JUN-21-2024										
6	CLIENT REVIEW [R1]	JUL-11-2024										
7	HR1	JUL-22-2024										
8	HR2	JUL-25-2024										



ALL IDEAS, DESIGNS, ARRANGEMENTS INDICATED ON THESE PROJECT DOCUMENTS ARE THE PROPERTY OF SEVENPOINT INTERIORS. DRAWINGS ARE FOR REFERENCE ONLY, ARE INTENDED TO BE USED WITH THIS SPECIFIC PROJECT, AND SHALL NOT OTHERWISE BE MODIFIED OR REPRODUCED FOR ANY PURPOSE WITHOUT THE WRITTEN AUTHORIZATION OF SEVENPOINT INTERIORS. SITE MEASURE IS REQUIRED BY TRADES PRIOR TO COMMENCING ANY WORK. DIMENSIONS ON DRAWINGS ARE ONLY APPROXIMATE. ALL VIEWS, DRAWINGS, DIAGRAMS ARE CONCEPTUAL AND MAY BE SUBJECT TO CHANGE. MATERIAL REFERENCE IMAGES ON SCREEN AND IN PRINT MAY DIFFER FROM ACTUAL PRODUCT. REFER TO PHYSICAL SAMPLE.

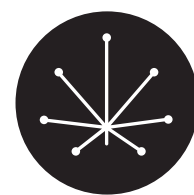

DESIGNED BY
SEVENPOINT INTERIORS

CONTACT
DESMOND@COFODESIGN.COM / JANE@COFODESIGN.COM

ADDRESS
21 REGINA ROAD, WOODBRIDGE, ONTARIO, CANADA, L4L 8L9



PROJECT
GREEN QWEEN - SHERMAN OAKS


CLIENT
TAYLOR BAZLEY / ANDRES RIGAL

ADDRESS
SHERMAN OAKS, CA

NO.	ISSUANCE	DATE	DRAWING TITLE		
4	MATERIALS REVIEW	JUN-13-2024	HIGH-RES RENDERING		
5	CLIENT REVIEW	JUN-21-2024			
6	CLIENT REVIEW (R1)	JUL-11-2024			
7	HR1	JUL-22-2024			
8	HR2	JUL-25-2024	SCALE	N/A	PAGE NO.
			RETAIL AREA	795 SQFT	22
			PROPOSAL NO.	XX-XXXX-XX	



ALL IDEAS, DESIGNS, ARRANGEMENTS INDICATED ON THESE PROJECT DOCUMENTS ARE THE PROPERTY OF SEVENPOINT INTERIORS. DRAWINGS ARE FOR REFERENCE ONLY, ARE INTENDED TO BE USED WITH THIS SPECIFIC PROJECT, AND SHALL NOT OTHERWISE BE MODIFIED OR REPRODUCED FOR ANY PURPOSE WITHOUT THE WRITTEN AUTHORIZATION OF SEVENPOINT INTERIORS. SITE MEASURE IS REQUIRED BY TRADES PRIOR TO COMMENCING ANY WORK. DIMENSIONS ON DRAWINGS ARE ONLY APPROXIMATE. ALL VIEWS, DRAWINGS, DIAGRAMS ARE CONCEPTUAL AND MAY BE SUBJECT TO CHANGE. MATERIAL REFERENCE IMAGES ON SCREEN AND IN PRINT MAY DIFFER FROM ACTUAL PRODUCT. REFER TO PHYSICAL SAMPLE.

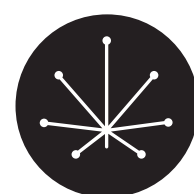

DESIGNED BY
SEVENPOINT INTERIORS

CONTACT
DESMOND@COFODESIGN.COM / JANE@COFODESIGN.COM

ADDRESS
21 REGINA ROAD, WOODBRIDGE, ONTARIO, CANADA, L4L 8L9



PROJECT
GREEN QWEEN - SHERMAN OAKS

CLIENT
TAYLOR BAZLEY / ANDRES RIGAL

ADDRESS
SHERMAN OAKS, CA

NO.	ISSUANCE	DATE	DRAWING TITLE	
4	MATERIALS REVIEW	JUN-13-2024	HIGH-RES RENDERING	
5	CLIENT REVIEW	JUN-21-2024		
6	CLIENT REVIEW [R1]	JUL-11-2024		
7	HR1	JUL-22-2024	SCALE	N/A
8	HR2	JUL-25-2024	RETAIL AREA	795 SQFT
			PROPOSAL NO.	XX-XXXX-XX


HIGH-RES RENDERING

PAGE NO.

23



ALL IDEAS, DESIGNS, ARRANGEMENTS INDICATED ON THESE PROJECT DOCUMENTS ARE THE PROPERTY OF SEVENPOINT INTERIORS. DRAWINGS ARE FOR REFERENCE ONLY, ARE INTENDED TO BE USED WITH THIS SPECIFIC PROJECT, AND SHALL NOT OTHERWISE BE MODIFIED OR REPRODUCED FOR ANY PURPOSE WITHOUT THE WRITTEN AUTHORIZATION OF SEVENPOINT INTERIORS. SITE MEASURE IS REQUIRED BY TRADES PRIOR TO COMMENCING ANY WORK. DIMENSIONS ON DRAWINGS ARE ONLY APPROXIMATE. ALL VIEWS, DRAWINGS, DIAGRAMS ARE CONCEPTUAL AND MAY BE SUBJECT TO CHANGE. MATERIAL REFERENCE IMAGES ON SCREEN AND IN PRINT MAY DIFFER FROM ACTUAL PRODUCT. REFER TO PHYSICAL SAMPLE.

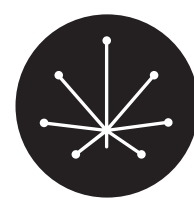

DESIGNED BY
SEVENPOINT INTERIORS

CONTACT
DESMOND@COFODESIGN.COM / JANE@COFODESIGN.COM

ADDRESS
21 REGINA ROAD, WOODBRIDGE, ONTARIO, CANADA, L4L 8L9



PROJECT
GREEN QWEEN - SHERMAN OAKS

CLIENT
TAYLOR BAZLEY / ANDRES RIGAL

ADDRESS
SHERMAN OAKS, CA

NO.	ISSUANCE	DATE	DRAWING TITLE	
4	MATERIALS REVIEW	JUN-13-2024	HIGH-RES RENDERING	
5	CLIENT REVIEW	JUN-21-2024		
6	CLIENT REVIEW (R1)	JUL-11-2024		
7	HR1	JUL-22-2024	SCALE	N/A
8	HR2	JUL-25-2024	RETAIL AREA	795 SQFT
			PROPOSAL NO.	XX-XXXX-XX